



ARCHITECTURE PLANNING INTERIOR DESIGN

15810 PARK TEN PLACE, SUITE 300
HOUSTON, TEXAS 77084
713-465-4650
www.sligroup.com


© COPYRIGHT

BAGEL BEE



400 W. DAVIS, SUITE 110
CONROE, TX 77301

E/B/E Project Number : 26049.00

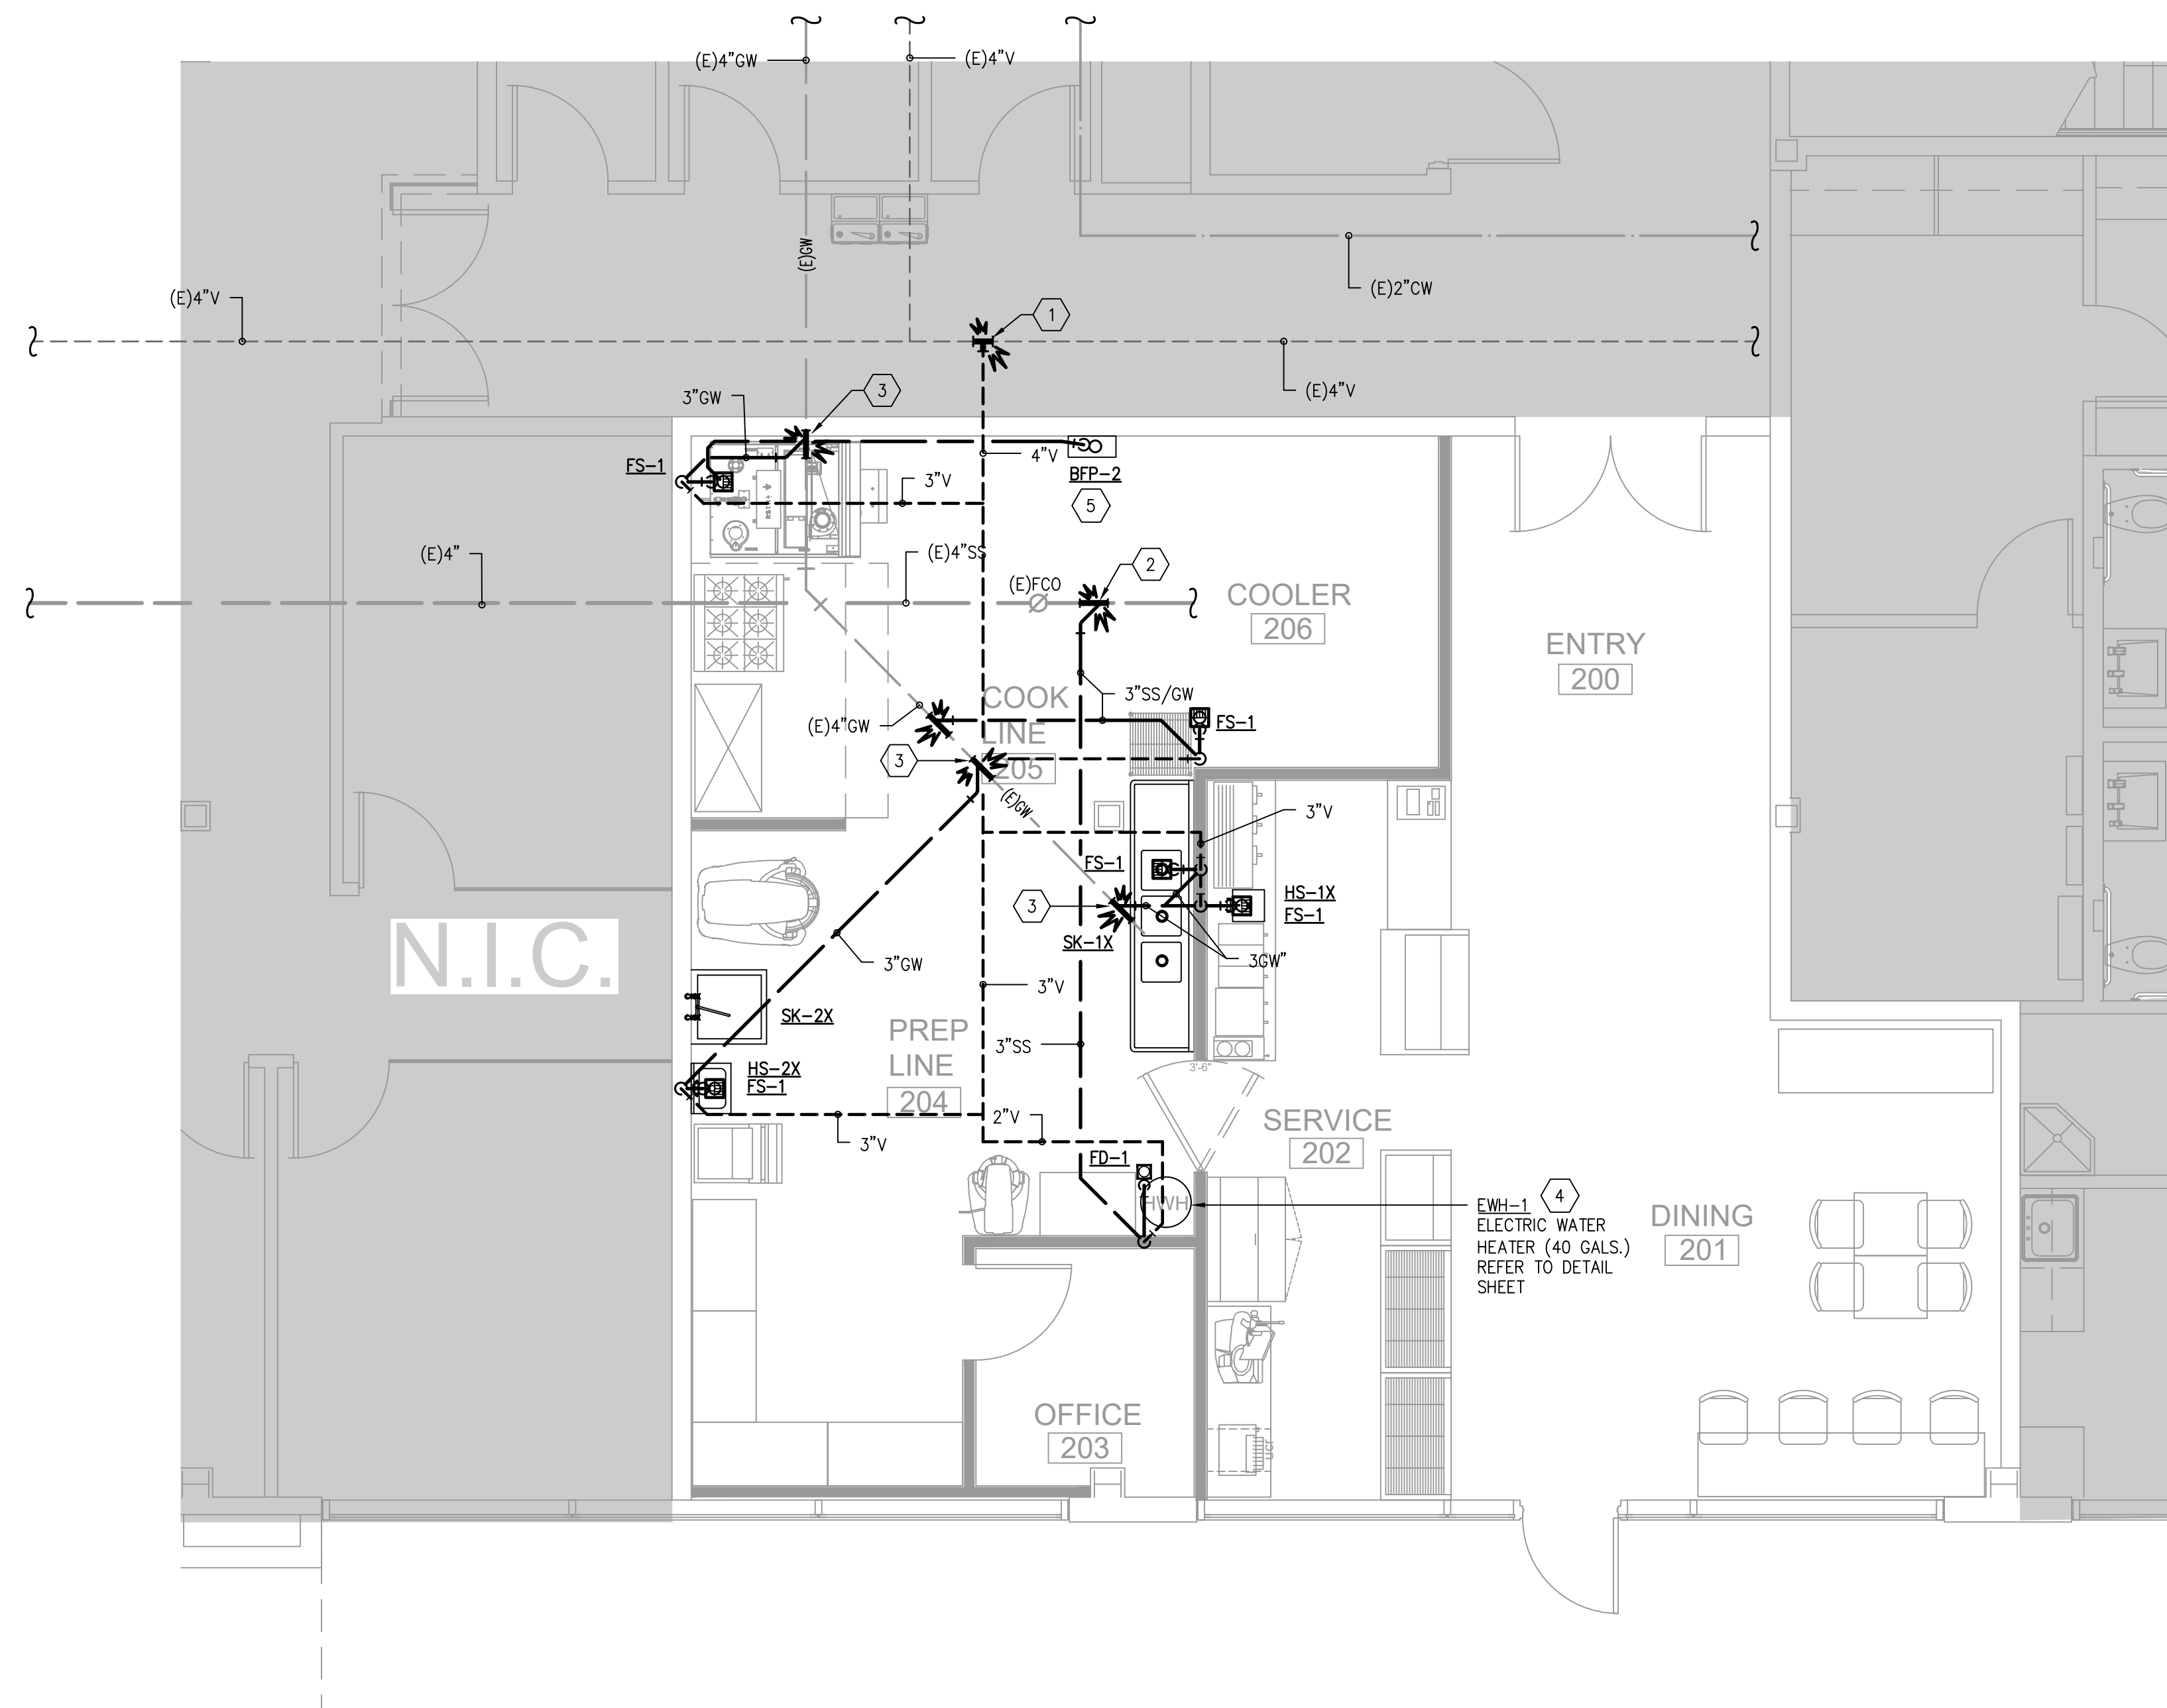

PLUMBING KEYED NOTES:

- 1 CONNECT NEW 2" VENT TO EXISTING VENT ABOVE CEILING. VERIFY SIZE AND LOCATION PRIOR TO START OF WORK.
- 2 CONNECT NEW 3" WASTE TO EXISTING WASTE BELOW FINISHED FLOOR. VERIFY SIZE AND LOCATION PRIOR TO START OF WORK.
- 3 CONNECT NEW 3" GREASE WASTE TO EXISTING GREASE WASTE BELOW FINISHED FLOOR. VERIFY SIZE AND LOCATION PRIOR TO START OF WORK.
- 4 NEW FLOOR MOUNTED WATER HEATER. COORDINATE WITH MEP IN THE AREA. REFER TO DETAIL SHEET.
- 5 CONTRACTOR TO PROVIDE AN INDIRECT WASTE RECEPTOR FOR BACKFLOW PREVENTOR AND ROUTE TO NEAREST FLOOR SINK.


ISSUED FOR CLIENT APPROVAL	DATE
ISSUED FOR BIDDING	05/08/2026
ISSUED FOR PERMIT	05/08/2026
ISSUED FOR CONSTRUCTION	

REVISIONS		
MARK	DESCRIPTION	DATE
	90% REVIEW SET	2026/04/07
	PERMIT AND BID SET	2026/05/08

The information, ideas, designs, details, layouts, techniques, features, arrangements, plans, sequences, dimensions, allowances, tolerances, conceptions, specifications, intentions, technology or embodiments, as illustrated, arranged, displayed, noted, recorded, indicated, represented, disclosed, evidenced, detailed or otherwise reduced to tangible form herein, either expressly, inherently or by implication, are the confidential and proprietary information of SLI Design, Inc. and shall not be used for any purpose other than the specific project or undertaking identified on the drawing title block or legend for which they are and have been prepared by SLI Design, Inc. Any other reproduction, disclosure or use of any portion of the confidential and proprietary information of SLI Design, Inc., shall be a breach of the obligation of confidence created by the acceptance of this drawing from SLI Design, Inc. for a specific project or contract. Any copying, duplicating, reproducing, utilization, alteration, modification, revision or change to this drawing, is expressly prohibited unless done with the prior written consent or approval of SLI Design, Inc. and shall not be undertaken without receipt of such prior written approval. This drawing is loaned by SLI Design, Inc., for the limited purpose of complying with a specific contract. The drawing remains the property of SLI Design, Inc. and shall be returned upon request or completion of the contract, unless specifically authorized by contract, under which it was loaned.

01 PLUMBING SANITARY PLAN - LEVEL 01
SCALE: 1/4"=1'-0"

 TRUE NORTH PLAN NORTH




SCALE: 1/4"=1'-0"



12603 Southwest Frwy, Ste 170, Stafford, Tx 77477
Tel: (713) 840-0177 / Firm Reg. No: 5638

PM	MECH	ELEC	PLBG	CHCK
JG	THV	JG	BM	JG

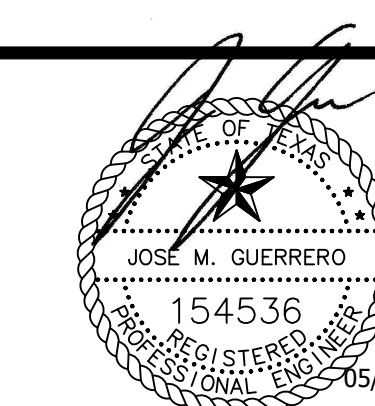

DRAWING TITLE
PLUMBING PLAN - SANITARY

SHEET NO.

P1.01