



ARCHITECTURE PLANNING INTERIOR DESIGN  
 15810 PARK TEN PLACE, SUITE 300  
 HOUSTON, TEXAS 77084  
 713-465-4650  
 www.sligroup.com

© COPYRIGHT

NECHES LUMBERTON OFFICE ADDITION  
 299 Country Lane at U.S. 69  
 Lumberton, Texas 77657



E/P/E PROJECT NUMBER: 26028.00

ISSUED FOR CLIENT APPROVAL	DATE
ISSUED FOR BIDDING	04/30/2026
ISSUED FOR PERMIT	04/30/2026
ISSUED FOR CONSTRUCTION	

REVISIONS

MARK	DESCRIPTION	DATE
	REVIEW SET	03-27-2026
	90% REVIEW SET	04-13-2026
	BID AND PERMIT	04-30-2026


The information, ideas, designs, details, layouts, techniques, features, arrangements, plans, sequences, dimensions, allowances, tolerances, conceptions, specifications, intentions, technology or embodiments, as illustrated, arranged, displayed, noted, recorded, indicated, represented, disclosed, evidenced, detailed or otherwise reduced to tangible form hereon, either expressly, inherently or by implication, are the confidential and proprietary information of SLI Design, Inc. and shall not be used for any purpose other than the specific project or undertaking identified on the drawing title block or legend for which they are and have been prepared by SLI Design, Inc. Any other reproduction, disclosure or use of any portion of the confidential and proprietary information of SLI Design, Inc., shall be a breach of the obligation of confidence created by the acceptance of this drawing from SLI Design, Inc. for a specific project or Contract. Any copying, duplicating, reproducing, utilization, alteration, modification, revision or change to this drawing, is expressly prohibited unless done with the prior written consent or approval of SLI Design, Inc. and shall not be undertaken without receipt of such prior written approval. This drawing is loaned by SLI Design, Inc., for the limited purpose of complying with a specific Contract. The drawing remains the property of SLI Design, Inc. and shall be returned upon request or completion of the contract, unless specifically authorized by Contract, under which it was loaned.

DESIGN TEAM  
 PM: JG  
 MECHANICAL: CC  
 ELECTRICAL: JG  
 PLUMBING: JG  
 CHECKED-BY: JG


DRAWING TITLE  
**PHOTOMETRICS - SITE**

SHEET NO.

**MEP-4.00**

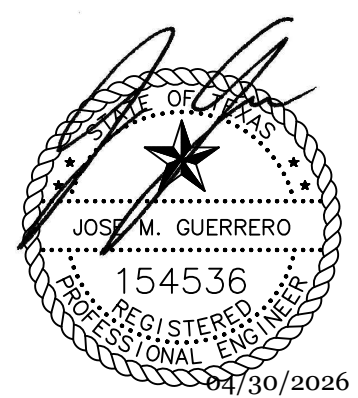

**E.I.B.E.** Mechanical  
 Electrical  
 Plumbing  
 CONSULTING ENGINEERS  
 12603 Southwest Frwy, Ste 170, Stafford, Tx 77477  
 Tel: (713) 840-0177 / Firm Reg. No: 5638

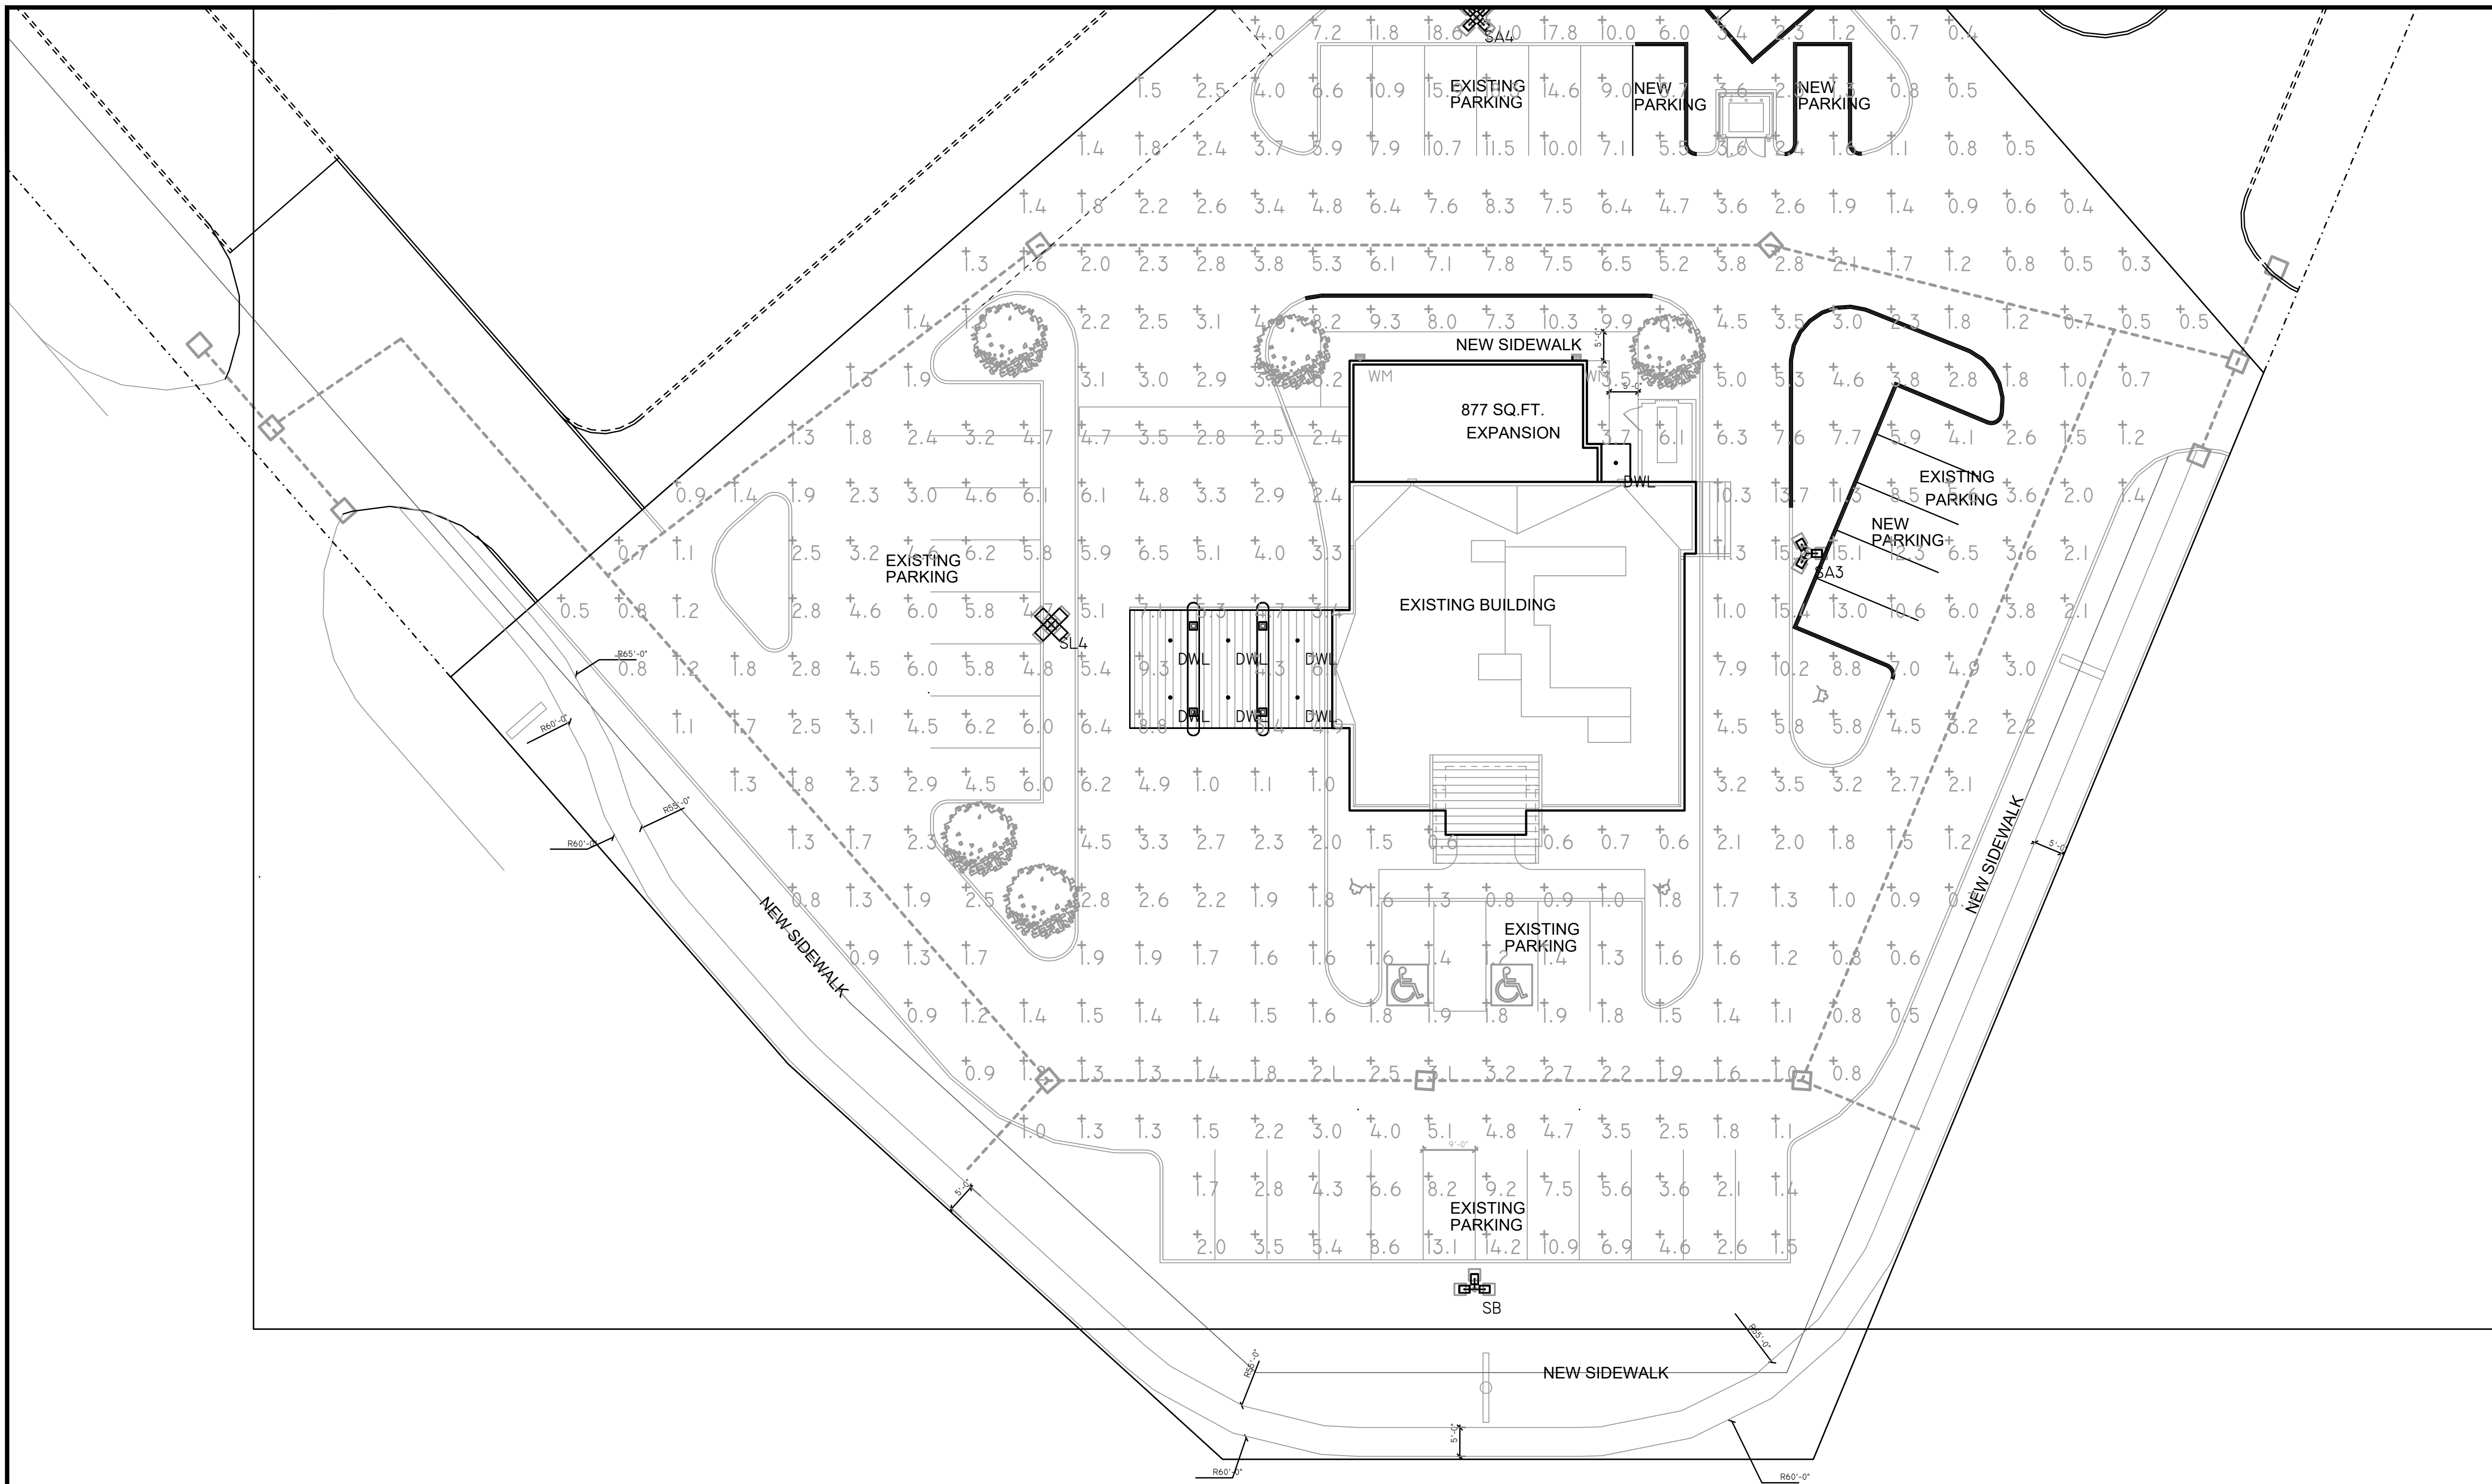

LUMINAIRE SCHEDULE

SYMBOL	QTY	LABEL	MOUNTING HEIGHT	ARRANGEMENT	DESCRIPTION	LLF	LUMINAIRE LUMENS
	2	WM	12	SINGLE	LSI P/N: XWM-FT-LED-08L-40-UE-FINISH	0.850	8605
	1	SA3	30	3 @ 120 DEGREES	TRU40PXX4F	0.600	28744
	1	SA4	30	4 @ 90 DEGREES	TRU40PXX4F	0.600	28744
	1	SB	30	3 @ 90 DEGREES	TRU40PXX4F	0.600	28744
	7	DWL	9, 9.5	SINGLE	WILLIAMS PN: 6DR-TL-L20/840-DIM-UNV-LW-OF-WH-AD-WET/CC-N-FI	0.850	1129
	1	SL4	30	4 @ 90 DEGREES	LSI P/N: XGBM-5W-LED-SS-NW-UE-BRZ	0.850	15173

CALCULATION SUMMARY

LABEL	CALCTYPE	UNITS	AVG	MAX	MIN	AVG/MIN	MAX/MIN
REVISED SITE	ILLUMINANCE	Fc	4	21.0	0.3	14	70