


- ELECTRICAL POWER KEYED NOTES:**
- 1 FACTORY SUPPLIED DISCONNECT INSTALLED BY ELECTRICAL CONTRACTOR.
 - 2 VERIFY THAT EXISTING RECEPTACLE EXISTS WITHIN 25' OF EQUIPMENT OTHERWISE INSTALL A NEW GFCI RECEPTACLE IN WEATHERPROOF ENCLOSURE AND CONNECT TO EXISTING ROOF RECEPTACLE CIRCUIT.
 - 3 PROVIDE 30A, NF/208V, 2-POLE/NEMA 1 DISCONNECT IN ACCESSIBLE LOCATION.
 - 4 RELOCATED SINK, FAUCET AND DISPOSAL EXTEND/REROUTE EXISTING DISPOSAL POWER TO NEW LOCATION AS NEEDED.

01 ELECTRICAL POWER PLAN
SCALE: 1/4"=1'-0"



02 ELECTRICAL POWER PLAN - ROOF
SCALE: 1/4"=1'-0"

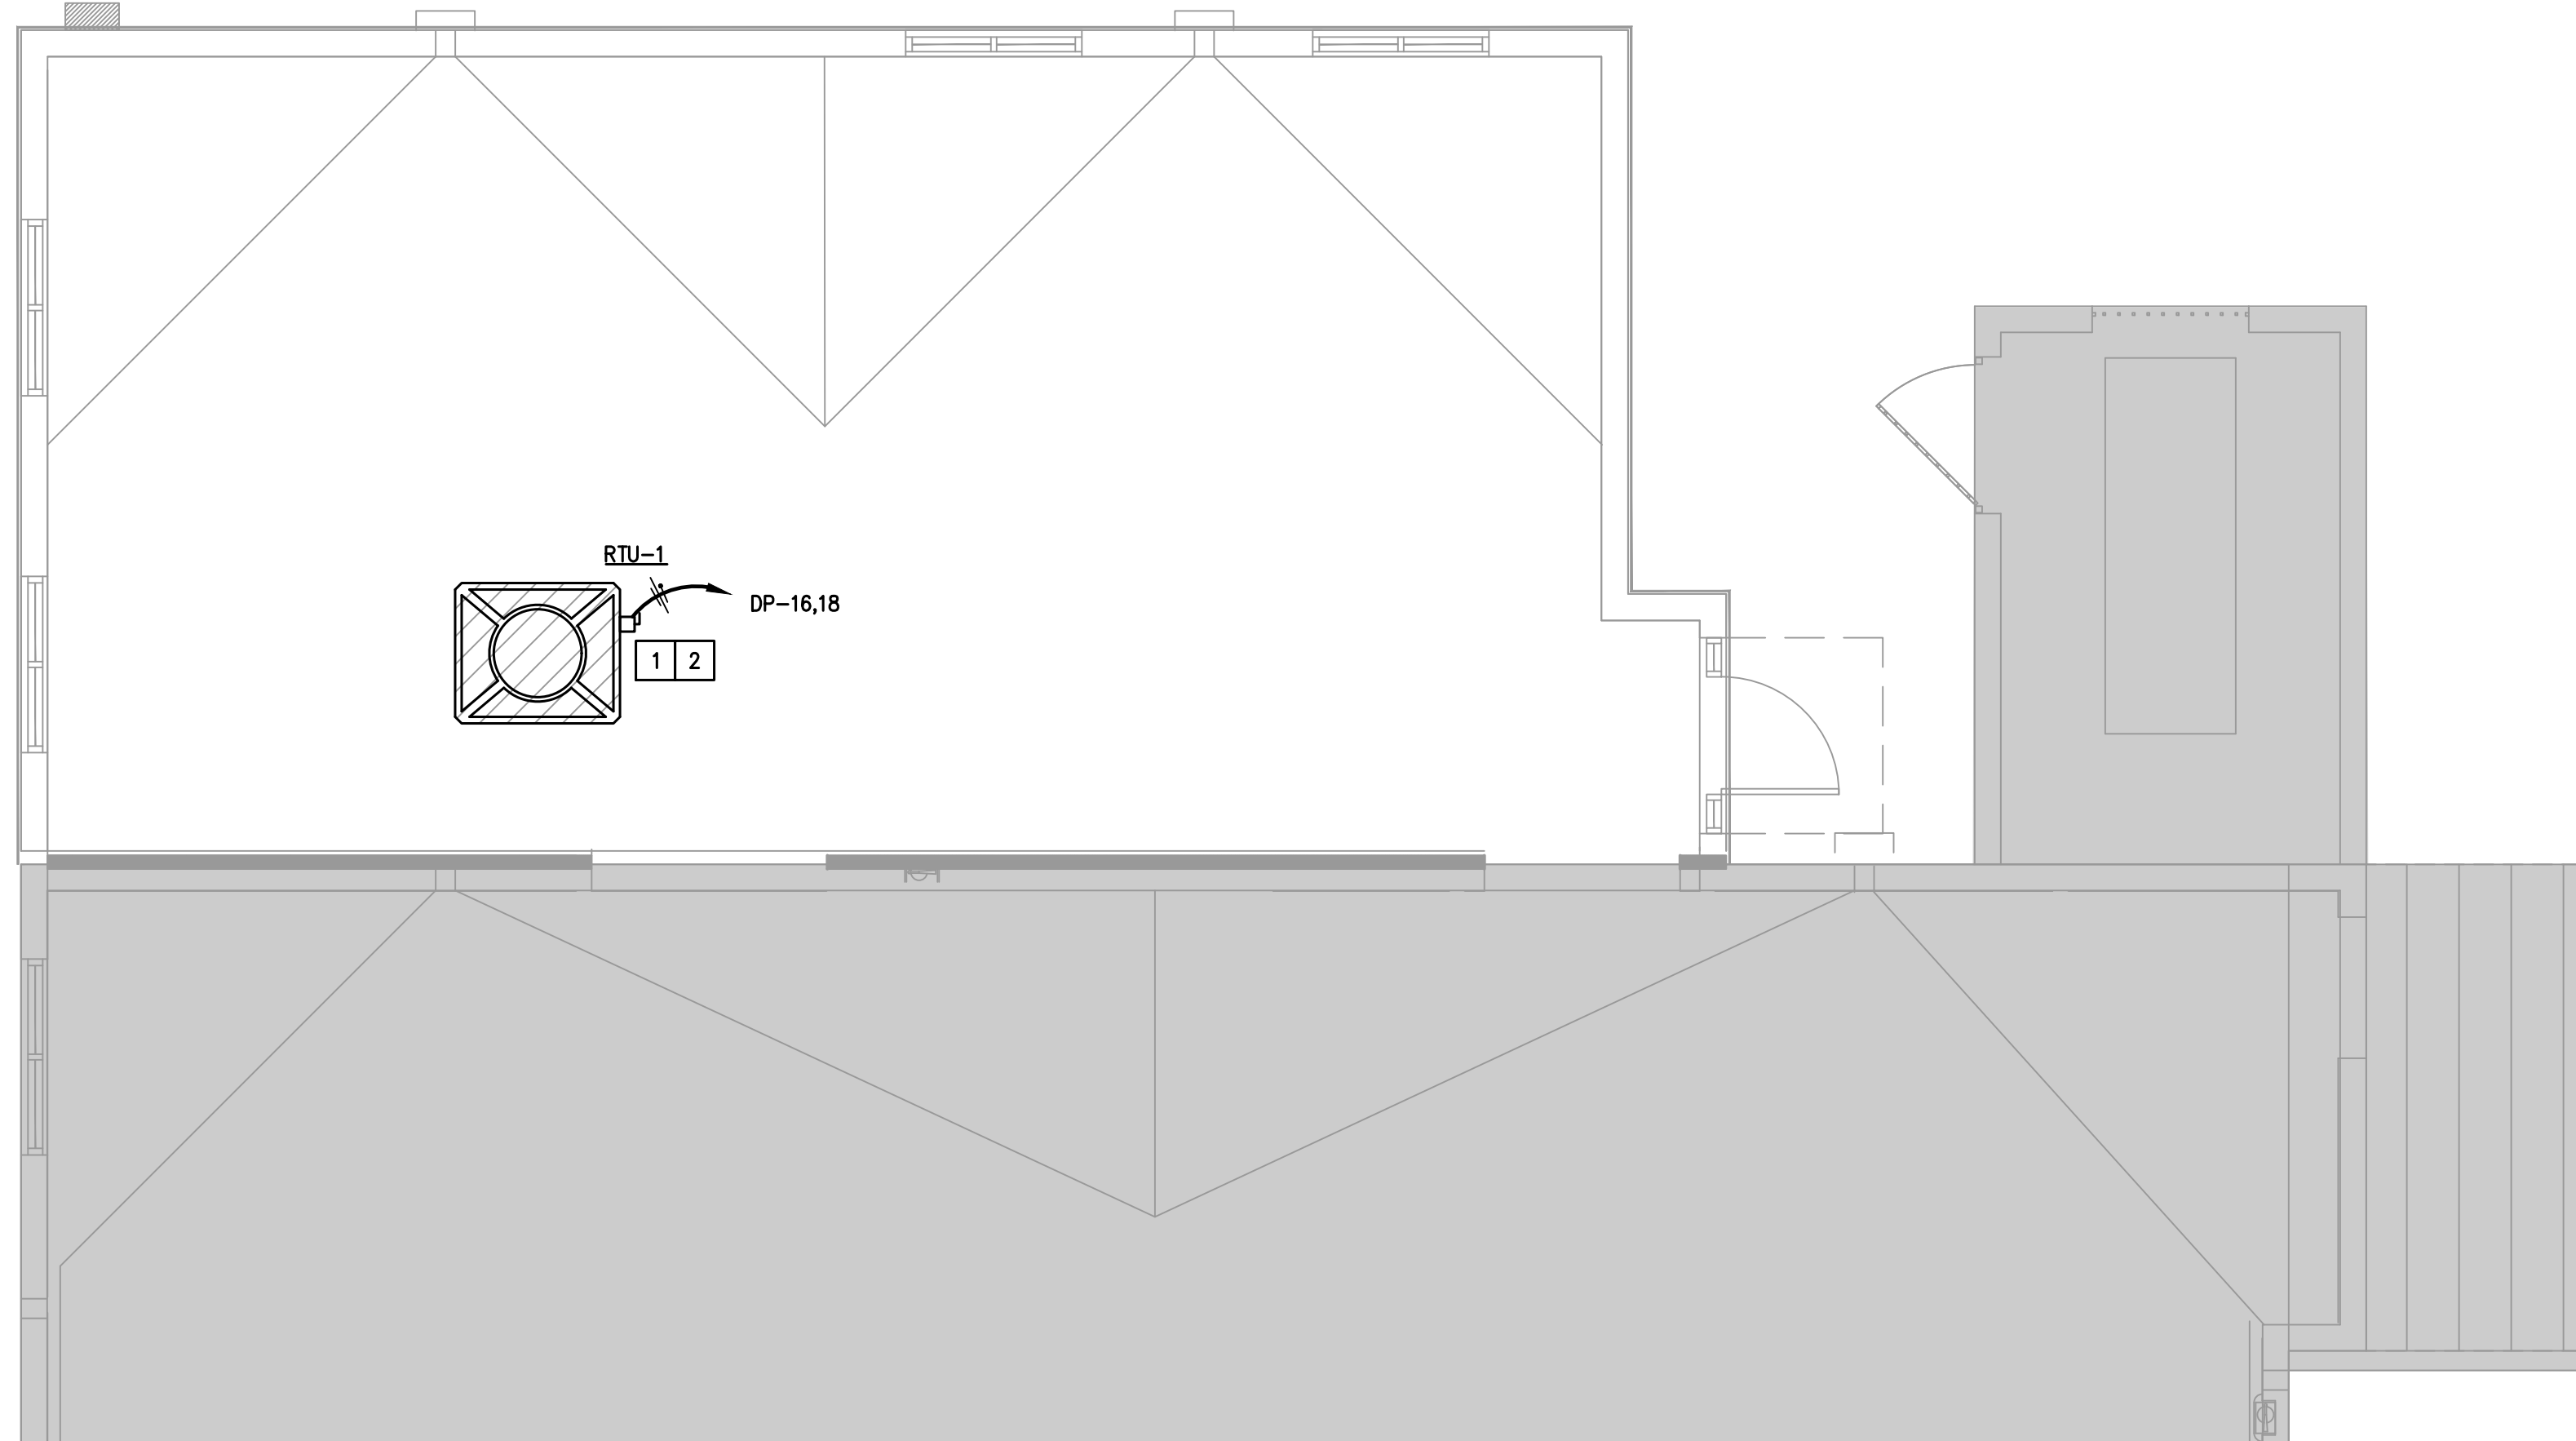

ARCHITECTURE PLANNING INTERIOR DESIGN
15810 PARK TEN PLACE, SUITE 300
HOUSTON, TEXAS 77084
713-465-4650
www.sligroup.com

NECHES LUMBERTON OFFICE ADDITION
299 Country Lane at U.S. 69
Lumberton, Texas 77657



ISSUED FOR CLIENT APPROVAL	DATE
ISSUED FOR BIDDING	04/30/2026
ISSUED FOR PERMIT	04/30/2026
ISSUED FOR CONSTRUCTION	

REVISIONS

MARK	DESCRIPTION	DATE
	REVIEW SET	03-27-2026
	90% REVIEW SET	04-13-2026
	BID AND PERMIT	04-30-2026

The information, ideas, designs, details, layouts, techniques, features, arrangements, plans, sequences, dimensions, allowances, tolerances, conceptions, specifications, intentions, technology or embodiments, as illustrated, arranged, displayed, noted, recorded, indicated, represented, disclosed, evidenced, detailed or otherwise reduced to tangible form hereon, either expressly, inherently or by implication, are the confidential and proprietary information of SLI Design, Inc. and shall not be used for any purpose other than the specific project or undertaking identified on the drawing title block or legend for which they are and have been prepared by SLI Design, Inc. Any other reproduction, disclosure or use of any portion of the confidential and proprietary information of SLI Design, Inc., shall be a breach of the obligation of confidence created by the acceptance of this drawing from SLI Design, Inc. for a specific project and Contract. Any copying, duplicating, reproducing, utilization, alteration, modification, revision or change to this drawing, is expressly prohibited unless done with the prior written consent or approval of SLI Design, Inc. and shall not be undertaken without receipt of such prior written approval. This drawing is loaned by SLI Design, Inc., for the limited purpose of complying with a specific Contract. The drawing remains the property of SLI Design, Inc. and shall be returned upon request or completion of the contract, unless specifically authorized by Contract, under which it was loaned.

DESIGN TEAM
PM: JG
MECHANICAL: CC
ELECTRICAL: JG
PLUMBING: JG
CHECKED-BY: JG

DRAWING TITLE
ELECTRICAL POWER PLAN

SHEET NO.

E-3.00

E|B|E Mechanical
Electrical
Plumbing
CONSULTING ENGINEERS
12603 Southwest Frwy, Ste 170, Stafford, Tx 77477
Tel: (713) 840-0177 / Firm Reg. No: 5638

