

FLOORING MATERIAL LEGEND

CODE	MFG	SERIES	COLOR	ITEM #	SIZE	NOTES	FLAME SPREAD & SMOKE DEVELOP INDEX
CA-1	EF CONTRACT	IMPRINT	MARINE	IMP45	18"X36"	ASHLAR INSTALL, .205" THICKNESS	CLASS 1 PER IBC 2015 SECTION 804.4.1,2
FT-1	DALTILE	LINDEN POINT	GRIGIO	LP21	12"X24"	3/8" THICKNESS, 3/16" GROUT LINE	
LVT-1	ADORE	NATURELLE PLUS	ADORN	NAT-2051	7"X48"	1/3 INSTALL, 3MM THICKNESS	CLASS 1 PER IBC 2015 SECTION 804.4.1,2

BASE MATERIAL LEGEND

CODE	MFG	SERIES	COLOR	ITEM #	SIZE	NOTES	FLAME SPREAD & SMOKE DEVELOP INDEX
RB-1	ROPPE	PINNACLE	BLACK BROWN	193	4"H	COIL MATERIAL	CLASS 1 PER IBC 2015 SECTION 804.4.1,2
TB-1	DALTILE	LINDEN POINT	GRIGIO	LP21	3"X12" BULLNOSE	5/16" THICKNESS, 3/16" GROUT LINE	CLASS 1 PER IBC 2015 SECTION 804.4.1,2

WALL MATERIAL LEGEND

CODE	MFG	SERIES	COLOR	ITEM #	SIZE	NOTES	FLAME SPREAD & SMOKE DEVELOP INDEX
FRP-1	GASLINER	FRP	WHITE			.090" THICKNESS	CLASS A PER IBC 2015 SECTION 803.9
GR-1	MAPEI	FLEXCOLOR CQ	SAHARA BEIGE	5011		3/16" THICKNESS	
PA-1	SHERWIN WILLIAMS	PRO MAR 200	EGRET WHITE	SW 7570		EGGSHELL FINISH	
PA-2	SHERWIN WILLIAMS	PRO MAR 200	COMMODORE	SW 6524		EGGSHELL FINISH	
PA-3	SHERWINWILLIAMS	PRO MAR 200	TRICON BLACK	SW 6258		EGGSHELL FINISH	
PA-4	SHERWINWILLIAMS	PRO MAR 200	ON THE ROCK	SW 7671			
WC-1	MOMENTUM	CUSTOM					
WT-1	MARAZZI	MODERN OASIS	SOFT CLOUD	MD05	12"X24"	5/16" THICKNESS, 3/16" GROUT LINE	
WT-2	MARAZZI	MODERN OASIS	SOFT CLOUD	P43C9	3"X12" BULLNOSE	5/16" THICKNESS, 3/16" GROUT LINE	INSTALL SCHLUTER J 100 ATGB TO TOP OF WALLTILE.

PLASTIC LAMINATE MATERIAL LEGEND

CODE	MFG	SERIES	COLOR	ITEM #	SIZE	NOTES	FLAME SPREAD & SMOKE DEVELOP INDEX
PL-1	WILSONART	STANDARD	PARK ELM	7967K-12		USE NON TEXTURED FINISH ON COUNTER TOPS	CLASS A ACCORDING TO NFPA 101. FLAME SPREAD LESS THAN 25 AND SMOKE DEVELOPED LESS THAN 450
PL-2	WILSONART	STANDARD	SATIN STAINLESS	4830K-18			CLASS A ACCORDING TO NFPA 101. FLAME SPREAD LESS THAN 25 AND SMOKE DEVELOPED LESS THAN 450
PL-3	WILSONART	STANDARD	PINNACLE WALNUT	7992-12		INTERIOR DOOR LAMINATE	CLASS A ACCORDING TO NFPA 101. FLAME SPREAD LESS THAN 25 AND SMOKE DEVELOPED LESS THAN 450
PL-4	WILSONART	STANDARD	SHADOW ZEPHYR	4857-60		DISPLAY CASE LAMINATE	CLASS A ACCORDING TO NFPA 101. FLAME SPREAD LESS THAN 25 AND SMOKE DEVELOPED LESS THAN 450

SOLID SURFACE MATERIAL LEGEND

CODE	MFG	SERIES	COLOR	ITEM #	SIZE	NOTES	FLAME SPREAD & SMOKE DEVELOP INDEX
ST-1	CAMBRIA		SWANBRIDGE				

WINDOW COVERING MATERIAL LEGEND

CODE	MFG	SERIES	COLOR	ITEM #	SIZE	NOTES	FLAME SPREAD & SMOKE DEVELOP INDEX
MB-1	BALI	CLASSIC	SILVER	737	1"	INSIDE MOUNTED, ALUMINUM VALANCE, EXTERIOR WINDOWS ONLY	
RS-1	SWF CONTRACT	ETERNITY	STEEL GREY	C1506		ALL CONFERENCE ROOM WINDOW	
WF-1	NATIONAL SOLUTIONS	OPTICALLY-CLEAR POLYESTER WINDOW FILM				OPACITY B	

APPLIANCE SCHEDULE

CODE	TYPE	MFG	MODEL #	ITEM #	FINISH	ROOMS	QTY
AP-1	TOP-FREEZER REFRIGERATOR W/ ADDED ICE MAKER	WHIRLPOOL	WRT311FZDZ	2592455	FINGERPRINT RESISTANT STAINLESS STEEL	BREAK ROOM 105	1

RESTROOM ACCESSORIES

 

NO.	MFG	DESCRIPTION	ITEM #	QTY
RA-1	AMERICAN STANDARDS	AUTOMATIC LIQUID SOAP AND GEL HAND SANITIZER DISPENSER – 27 OZ. – STAINLESS STEEL – SURFACE OR STAND MOUNTED	0362	2
RA-2	AMERICAN STANDARDS	36" LONG 1-1/2" DIA – SNAP FLANGE MOUNT GRAB BARS	3801-36	2
RA-3	AMERICAN STANDARDS	42" LONG 1-1/2" DIA – SNAP FLANGE MOUNT GRAB BARS	3801-42	2
RA-4	American Specialties Inc.	TOILET TISSUE DISPENSER - TWIN HIDE-A-ROLL - SURFACE MOUNTED	0030	2
RA-5	American Specialties Inc.	Traditional™ - Paper Towel Dispenser & Waste Receptacle - Multi, C-Fold - 12 gal. - Recessed (04697)	4697	2
RA-6	American Specialties Inc.	Baby Changing Station - Horizontal - Stainless Steel - Recessed (9013)	9013	2

ROOM FINISH SCHEDULE

NO.	ROOM	FLOOR	BASE	WALL ►	WALL ▲	WALL ◄	WALL ▼	CEILING
100A	VESTIBULE/ITM	LVT-1	RB-1	PA-2	PA-1	PA-1	PA-1	
100B	LOBBY	CA-1	RB-1	PA-1	PA-1/WC-1	PA-1, PA-2	PA-1	PA-1
101	OFFICE	CA-1	RB-1	PA-1	PA-1	PA-1	PA-1	
101A	ATM	LVT-1	RB-1	PA-1	PA-1	PA-1	PA-1	
102	OFFICE	CA-1	RB-1	PA-1	PA-1	PA-1	PA-1	
103	OFFICE	CA-1	RB-1	PA-1	PA-1	PA-1	PA-1	
104	OFFICE	CA-1	RB-1	PA-1	PA-1	PA-1	PA-1	
105	BREAK ROOM	LVT-1	RB-1	PA-1	PA-1	PA-1	PA-1	
106	JAN.	LVT-1	RB-1	PA-1	PA-1, FRP-1	PA-1, FRP-1	PA-1	
107	DATA	LVT-1	RB-1	PA-1	PA-1	PA-1	PA-1	
108	STORAGE	LVT-1	RB-1	PA-1	PA-1	PA-1	PA-1	
109	ELEC	LVT-1	RB-1	PA-1	PA-1	PA-1	PA-1	
110	WORK AREA	LVT-1	RB-1	PA-1	PA-1	PA-1	PA-1	
111	HALL	LVT-1	RB-1	PA-1	PA-1	PA-1	PA-1	
112	MEN	FT-1	TB-1	PA-1, WT-1, WT-2	PA-1	PA-1	PA-1, WT-1, WT-2	
113	WOMEN	FT-1	TB-1	PA-1, WT-1, WT-2	PA-1, WT-1, WT-2	PA-1	PA-1	
114	CONFERENCE	CA-1	RB-1	PA-1	PA-1	PA-1	PA-1	

GENERAL NOTES

NO.	DESCRIPTION
1	SUBMIT A 12"X12" SAMPLE OF WALL FINISHES TO SLI FOR APPROVAL
2	PROVIDE SHOP DRAWINGS FOR ALL PLASTIC LAMINATE CASE GOODS
3	ALL CARPET/VCT TRANSITIONS TO BE FLUSH
4	RUBBER TRANSITION STRIPS TO BE INSTALLED ALL OTHER TRANSITIONS; CERAMIN TO VCT
5	RUBBER TRANSITION STRIPS TO BE INSTALLED ALL OTHER TRANSITIONS; RUBBER TILE TO GLUE DOWN CARPET
6	ALL GROUT LINES TO BE SEALED
7	ALL WALL COVERING MATERIAL SUPPLIED AND INSTALLED BY SLI
8	RENO TX SCHLUTER MATERIAL TRANSITIONA STRIP TO BE INSTALLED BETWEEN CERAMIC TILE AND GLUE-DOWN CARPET
9	ALL VCT TO BE SEALED WITH 3-5 COATS OF WAX, BUFF BETWEEN COATS
10	ANY REMAINING MATERIAL TO BE GIVEN TO CLIENT AS ATTIC STOCK
11	WALKING SURFACES ALONG PATH OF EGRESS SHALL BE NON-SLIP AND ADHERED SECURELY PER IBC 2015 SECTION 1003.4
12	

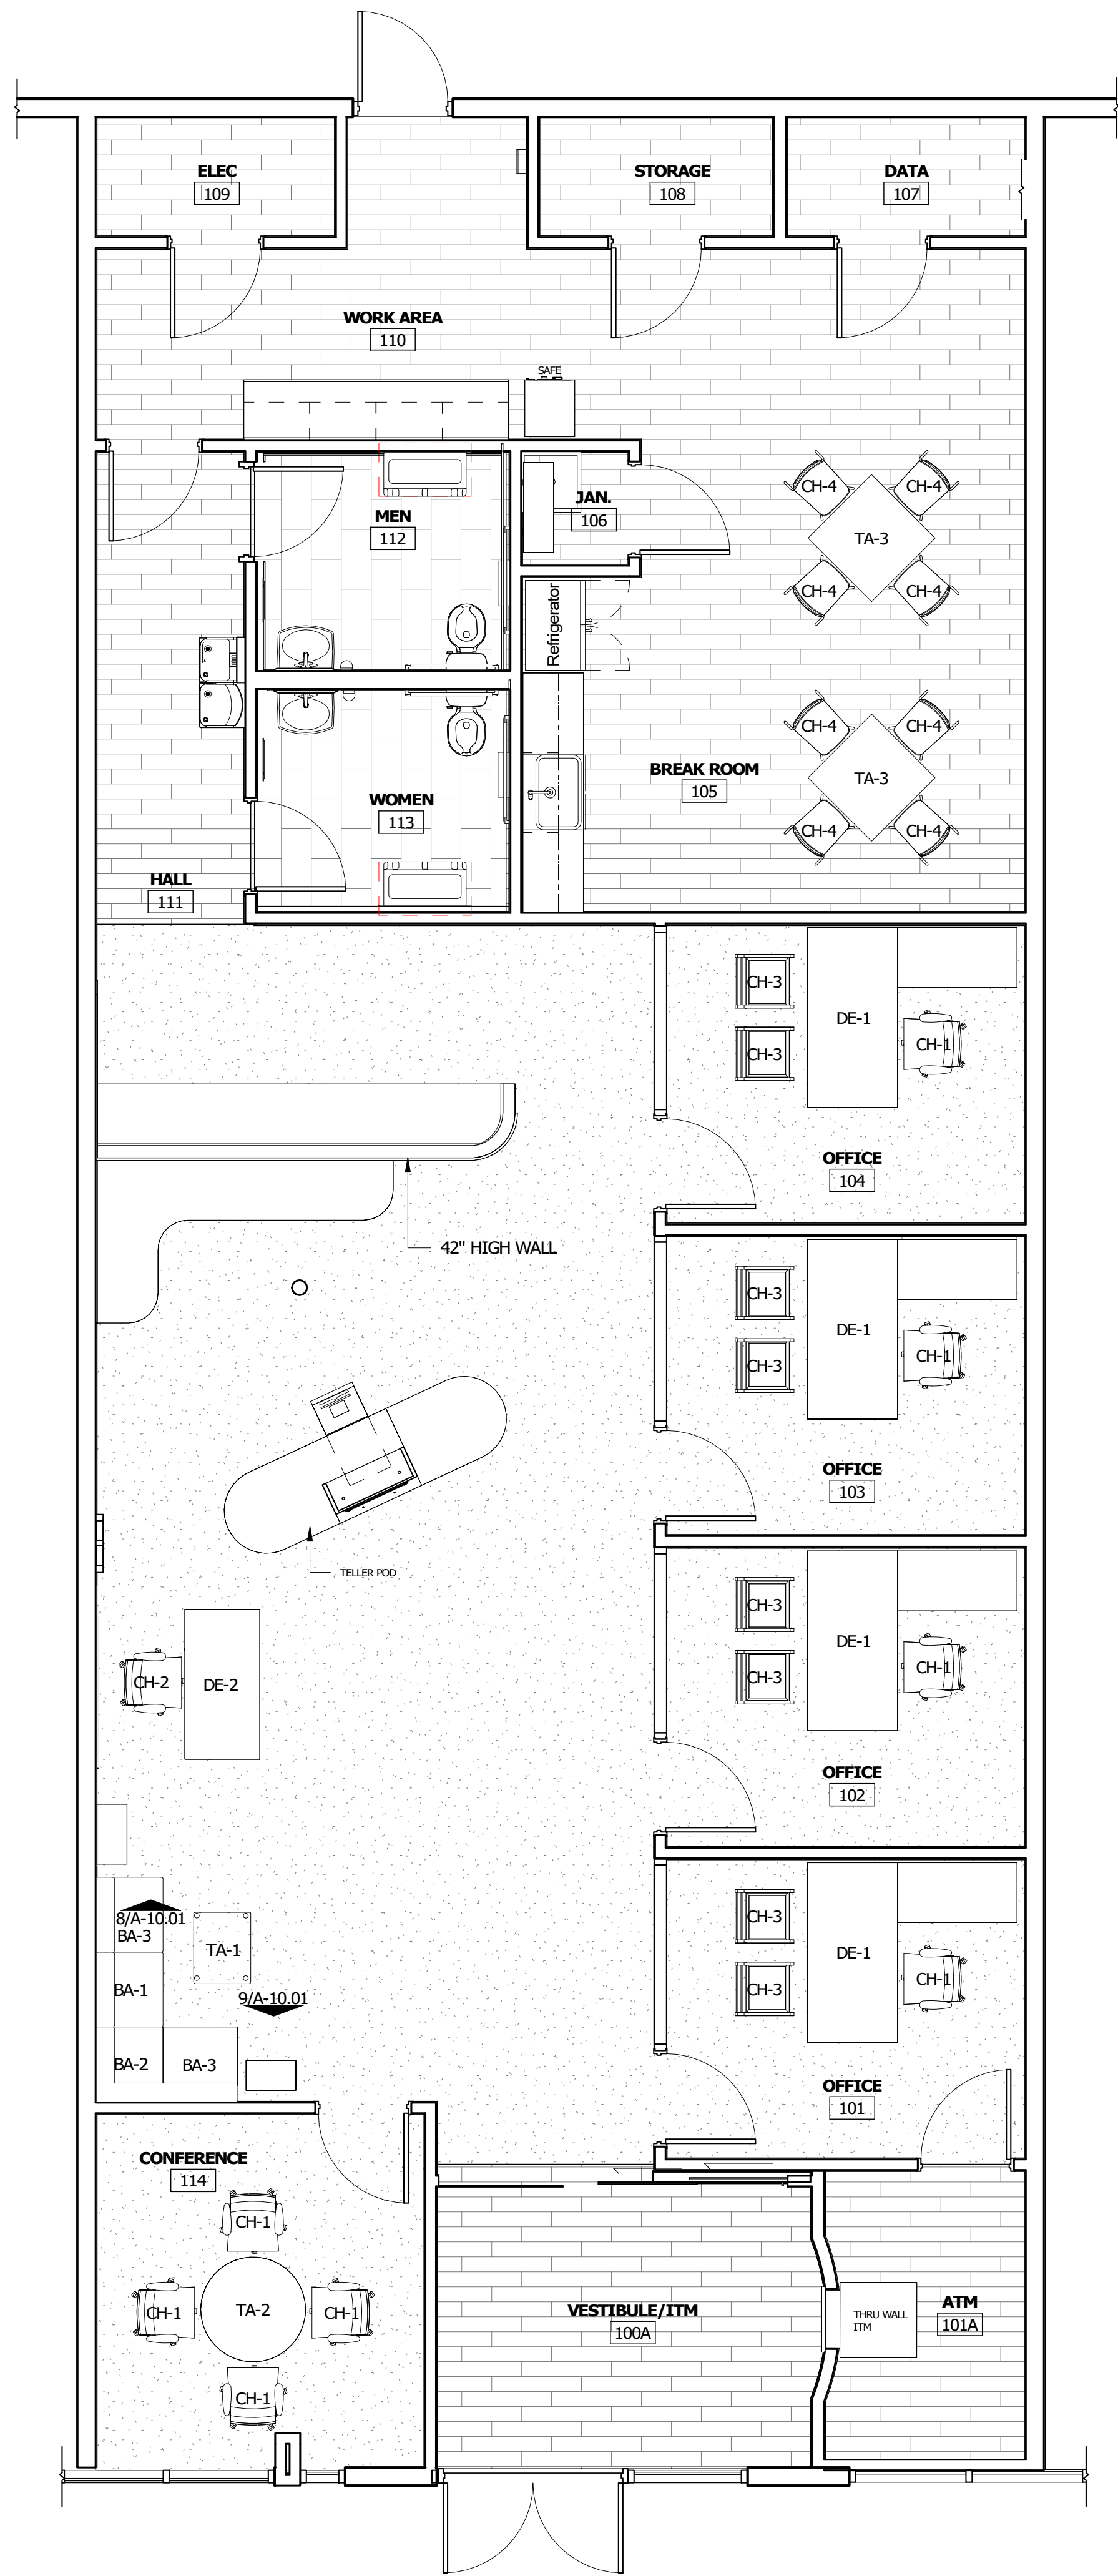

ISSUED FOR CLIENT APPROVAL	DATE
ISSUED FOR BIDDING	07/13/26
ISSUED FOR PERMIT	07/13/26
ISSUED FOR CONSTRUCTION	

[illegible]

The information, ideas, designs, details, layouts, techniques, features, arrangements, plans, sequences, dimensions, allowances, tolerances, conceptions, calculations, drawings, sketches, notes, data, information, and/or materials, displayed, noted, recorded, indicated, represented, disclosed, evidenced, demonstrated or otherwise reduced to tangible form herein, either expressly, inherently or by implication, are the confidential and proprietary information of SSI Design, Inc., and shall be held in confidence by the undersigned. The undersigned hereby certifies and identifies on the drawing title block or legend for which they are and have been prepared by SSI Design, Inc. Any other reproduction, disclosure or use of any portion of the confidential and proprietary information of SSI Design, Inc., shall be held in confidence by the undersigned. The undersigned hereby certifies that SSI Design, Inc. is a specific project or Contract. Any copying, duplicating, reproducing, utilization, alteration, modification, revision or change to this drawing is expressly prohibited unless with the prior written consent and approval of SSI Design, Inc. The undersigned understands and accepts such prior written approval. This drawing is owned by SSI Design, Inc., for the limited purpose of complying with a specific Contract. The drawing remains the property of SSI Design, Inc. and shall be held in confidence by the undersigned. This contract, unless specifically authorized by Contract, under which it was issued.

PRINT DATE: 7/13/2026 3:36:00 PM

DRAWING TITLE		SHEET NO. A-12.00
FINISHED FLOOR		
DRAWN BY	XX	
CHECKED BY	XX	
APPROVED BY	XX	