

	DATE
ISSUED FOR CLIENT APPROVAL	06/24/2026
ISSUED FOR BIDDING	06/24/2026
ISSUED FOR PERMIT	06/24/2026
ISSUED FOR CONSTRUCTION	07/13/2026

REVISIONS

[illegible]


DRAWING TITLE

MECHANICAL DETAILS

DESIGN TEAM
P.M.: JG
MECHANICAL: CC
ELECTRICAL: JG
PLUMBING: CC
CHECKED-BY: JG

SHEET NO.


M-3.00

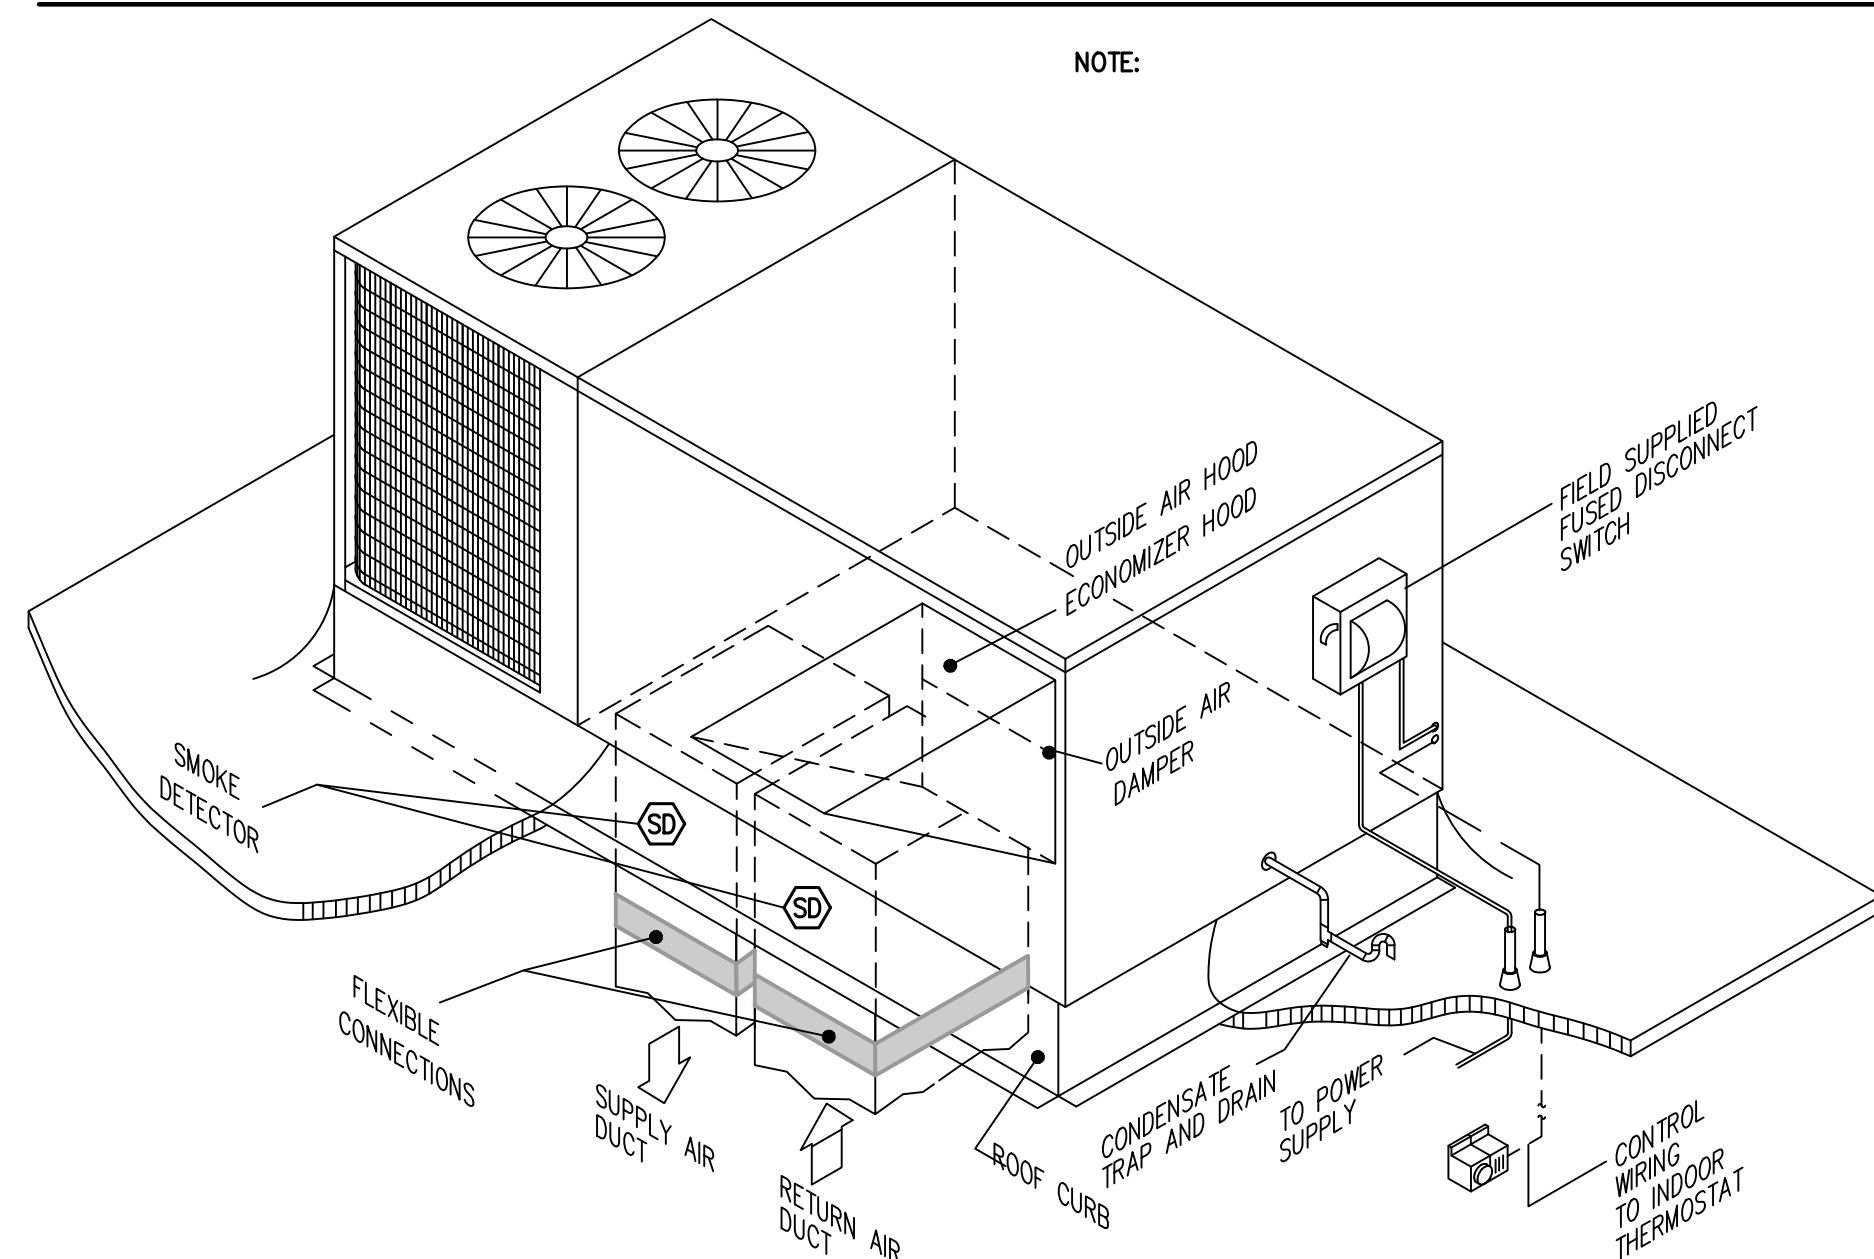

ROOFTOP PACKAGED HVAC UNIT DETAIL

SCALE: NONE

07

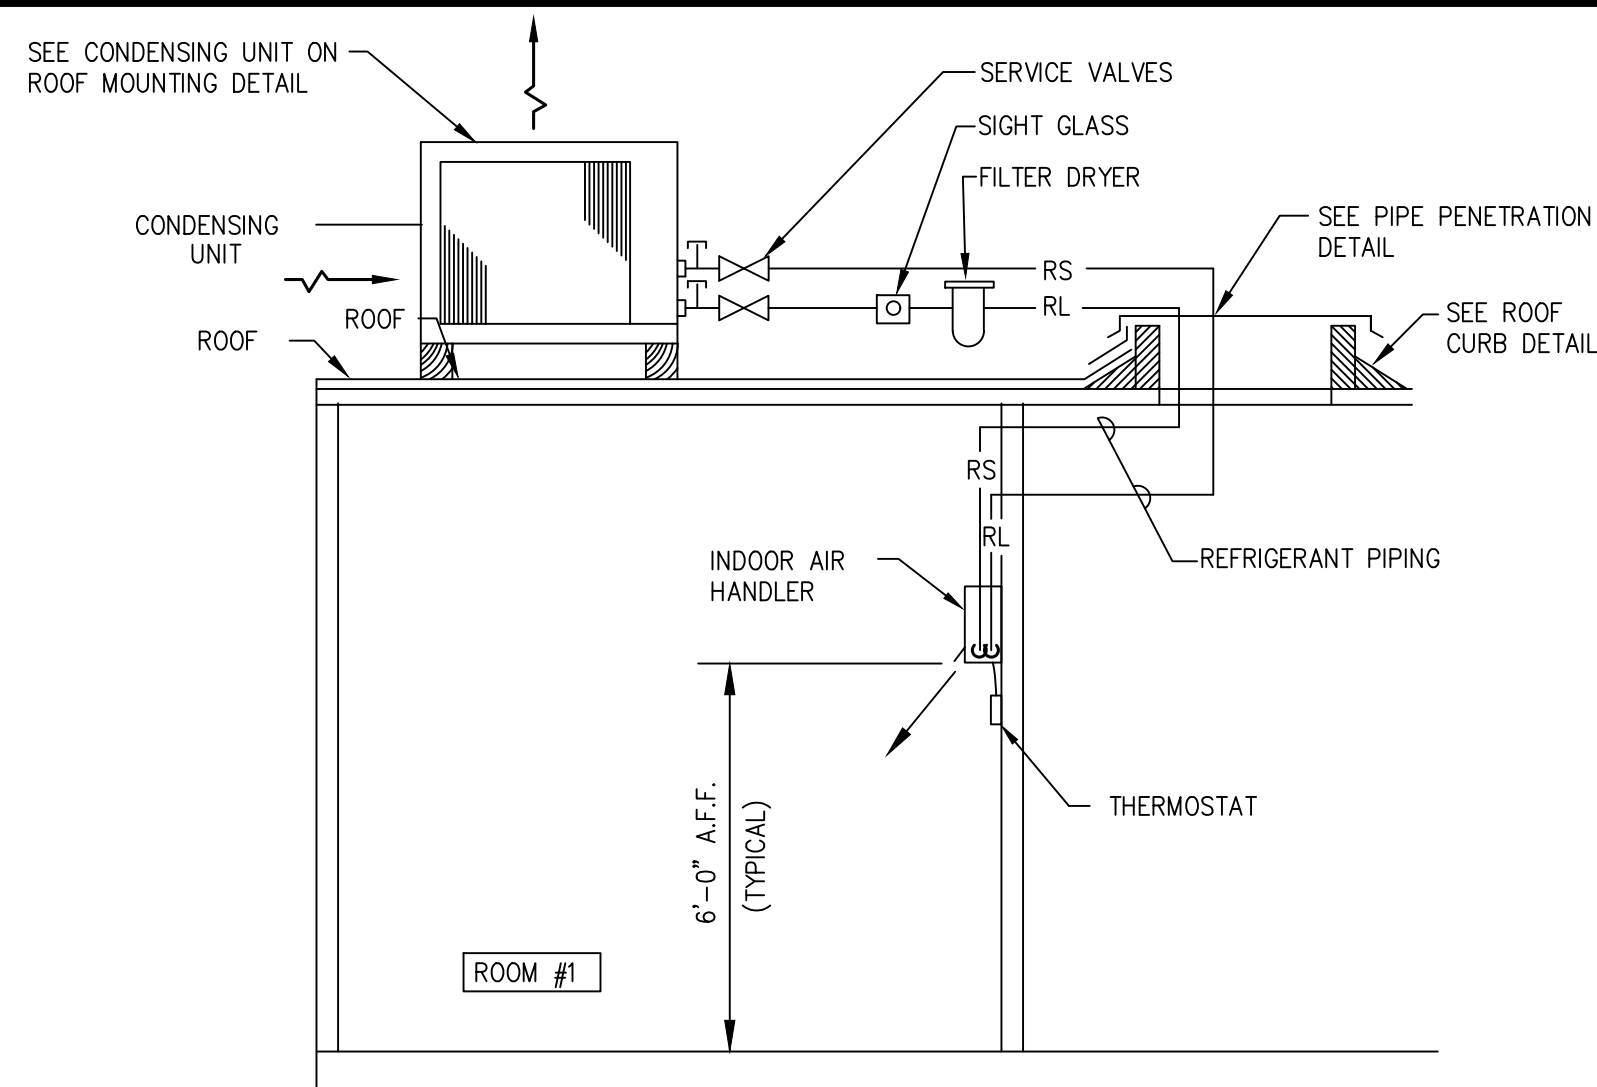

A/C SYSTEM WALL MOUNTED AIR HANDLING + ROOF MOUNTED CONDENSING UNIT

SCALE: NONE

08