


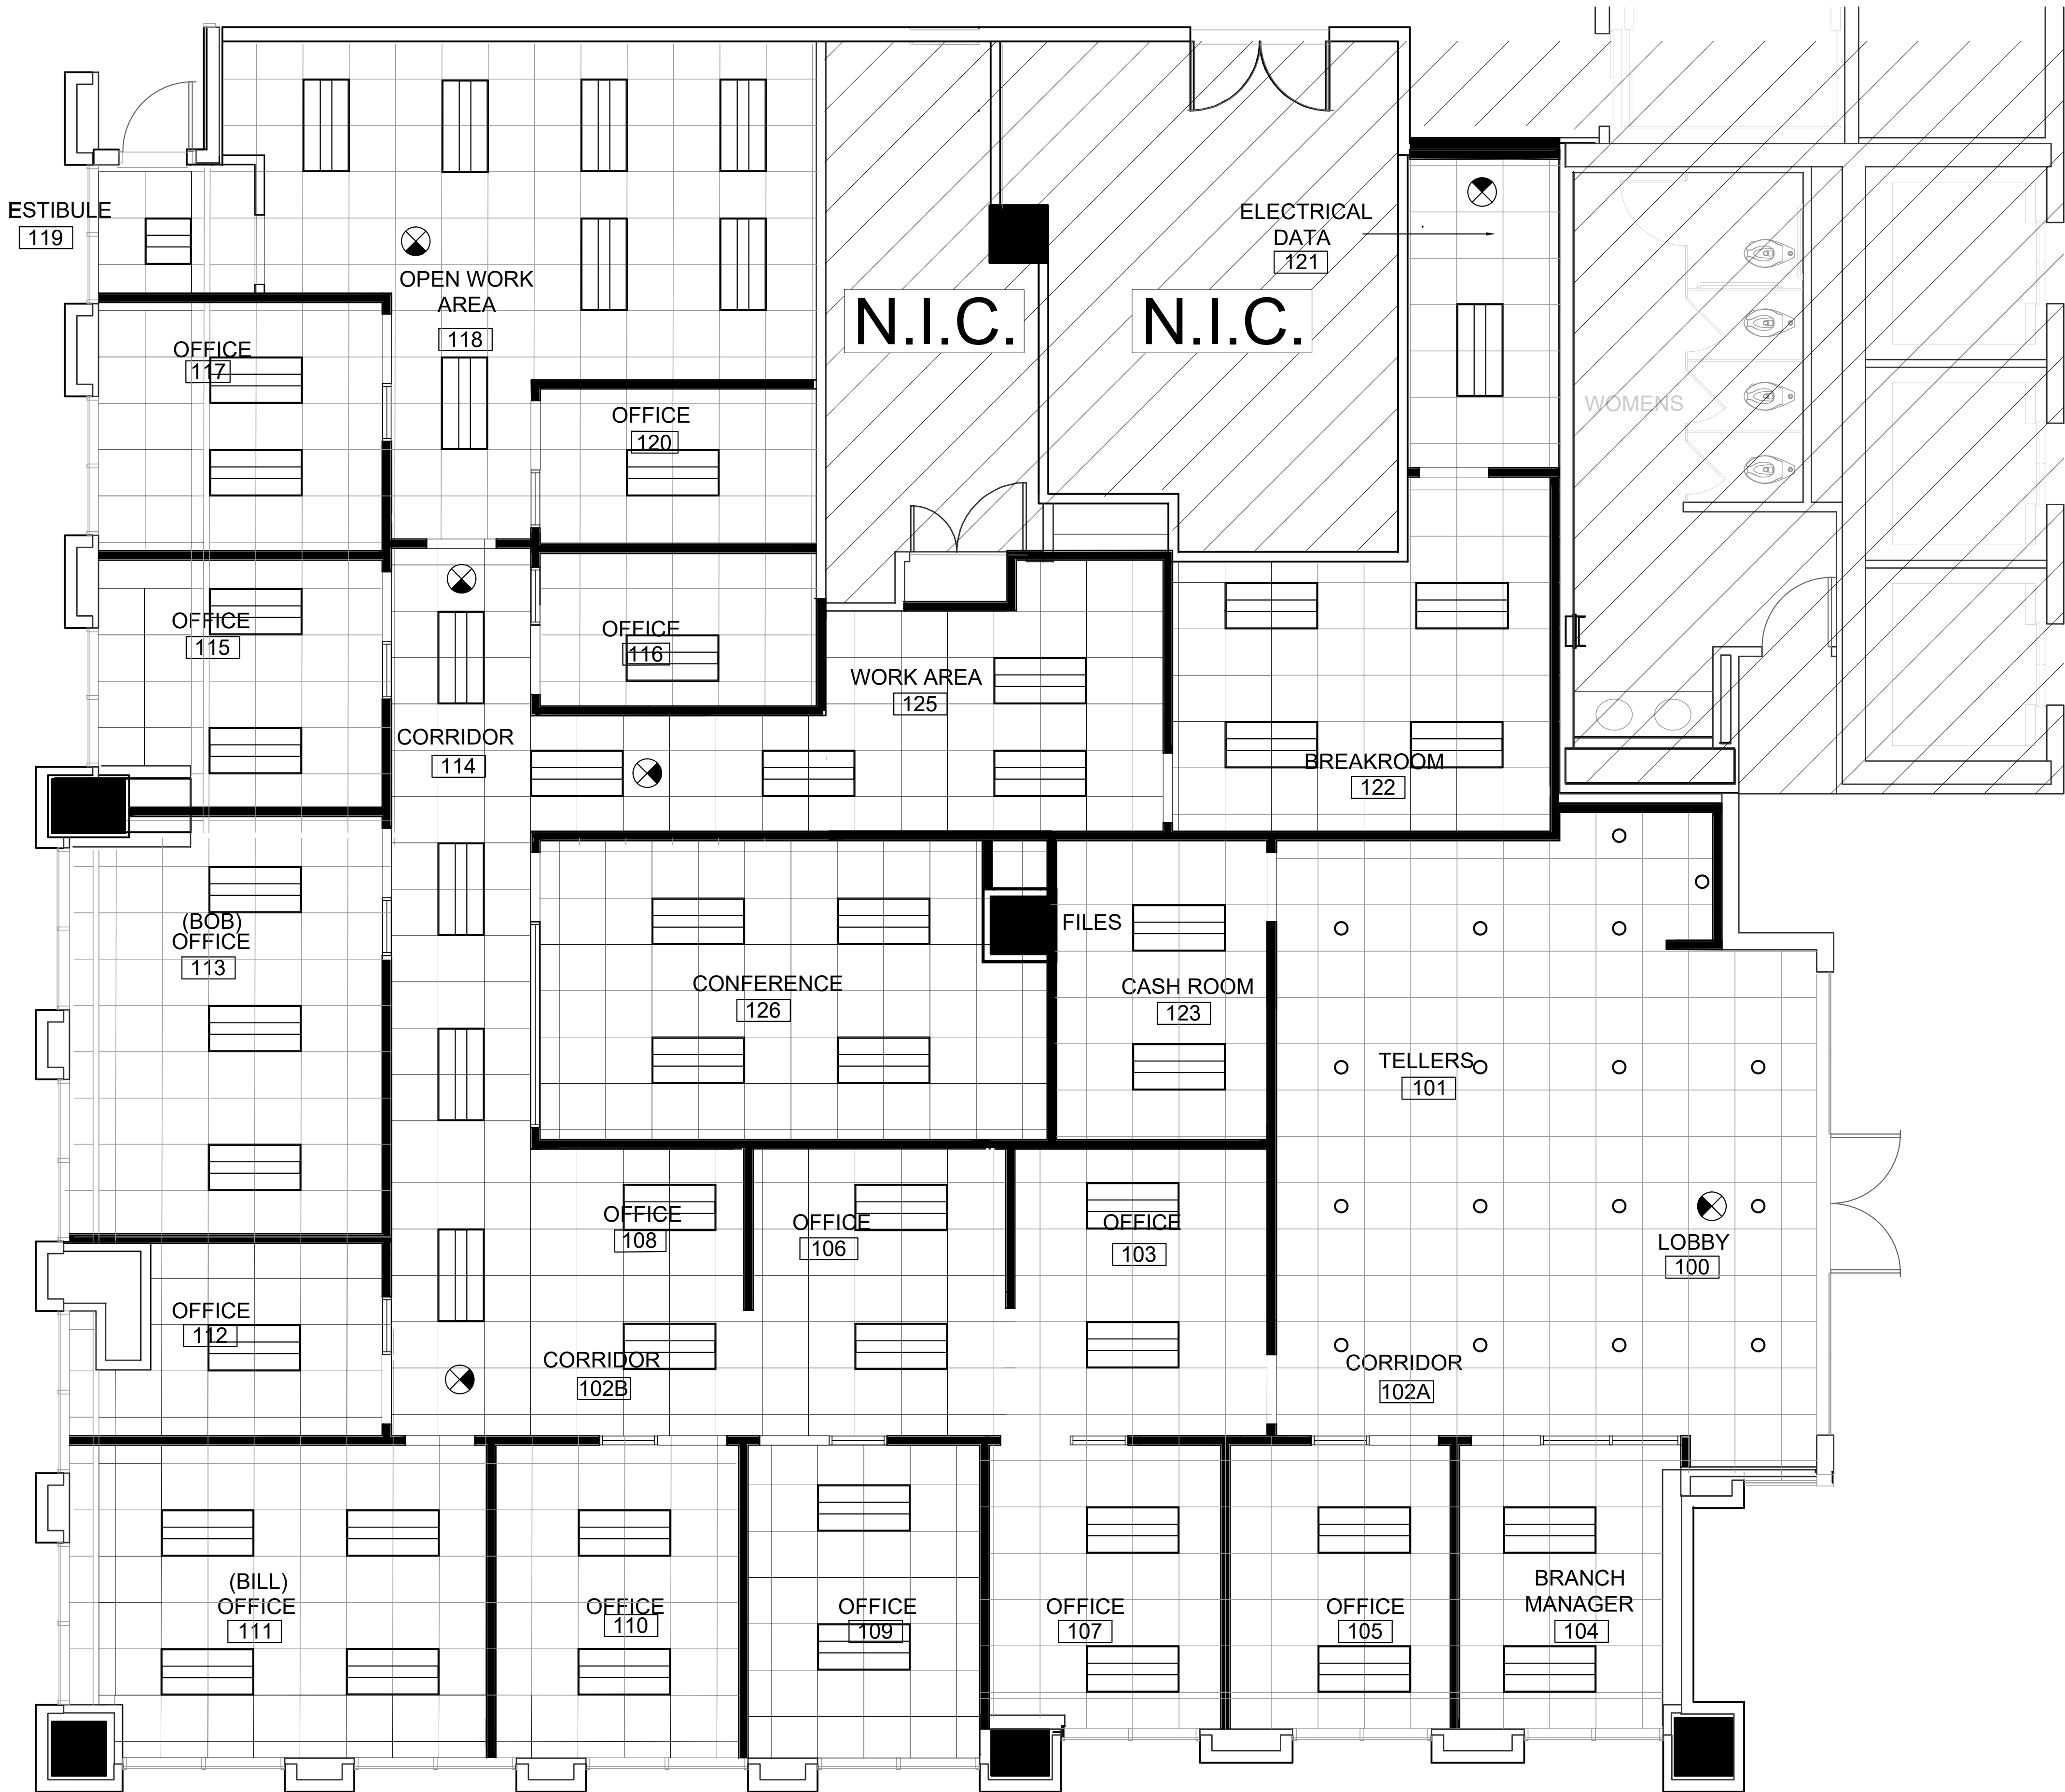

- GENERAL NOTES:
- CENTER GRID IN EACH ROOM (TYPICAL) U.N.O.
 - CEILING HEIGHT TO MATCH EXISTING AT 12'-0" A.F.F. U.N.O.

CEILING LEGEND	
SYMBOL	DESCRIPTION
	2x2' CEILING TILE AND WHITE GRID. NEW TO MATCH EXISTING.

LIGHTING LEGEND	
SYMBOL	DESCRIPTION
	2x4' RECESSED LED FIXTURE; RE:ELECTRICAL DRAWINGS
	2x4' RECESSED LED FIXTURE WITH EMERGENCY BACKUP; RE:ELECTRICAL DRAWINGS
	RECESSED CAN LIGHT FIXTURE; RE:ELECTRICAL DRAWINGS
	2x2' RECESSED LED FIXTURE WITH EMERGENCY BACKUP; RE:ELECTRICAL DRAWINGS



ARCHITECTURE | DESIGN | CONSTRUCTION.
15810 PARK TEN PLACE, SUITE 300
HOUSTON, TEXAS 77084
713-465-4650
www.sligroup.com

© COPYRIGHT

ALBA BANK
11700 Katy Freeway
Suite 175
Houston TX 77079

PROJECT NUMBER:

ISSUED FOR CLIENT APPROVAL DATE

ISSUED FOR BIDDING

ISSUED FOR PERMIT

ISSUED FOR CONSTRUCTION

REVISIONS

MARK DESCRIPTION DATE

01 RCP
SCALE: 1/4" = 1'-0"

DRAWING TITLE
REFLECTED CEILING PLAN

DRAWN BY JB

CHECKED BY BL

APPROVED BY BL

SHEET NO.

A-4.00