



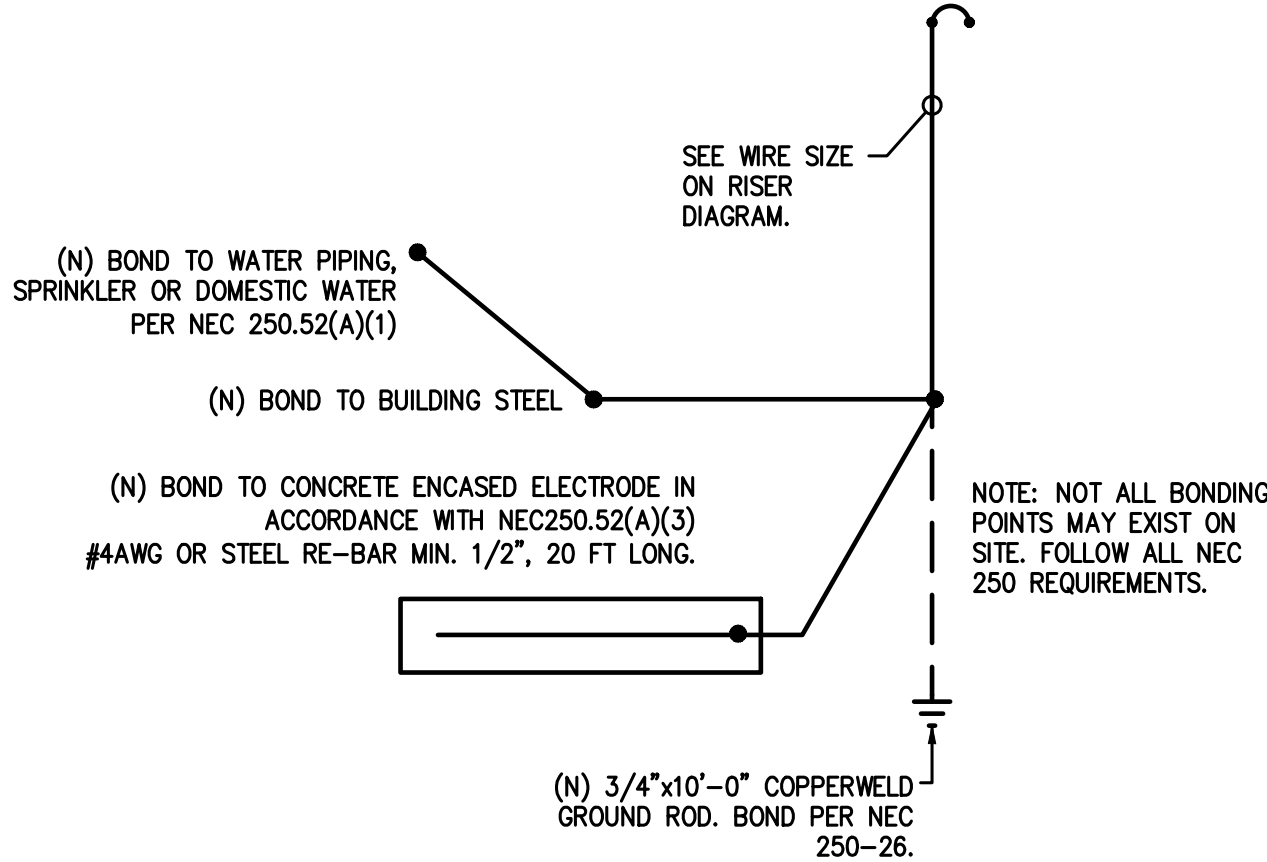

GROUNDING DETAIL

SCALE: NONE


1

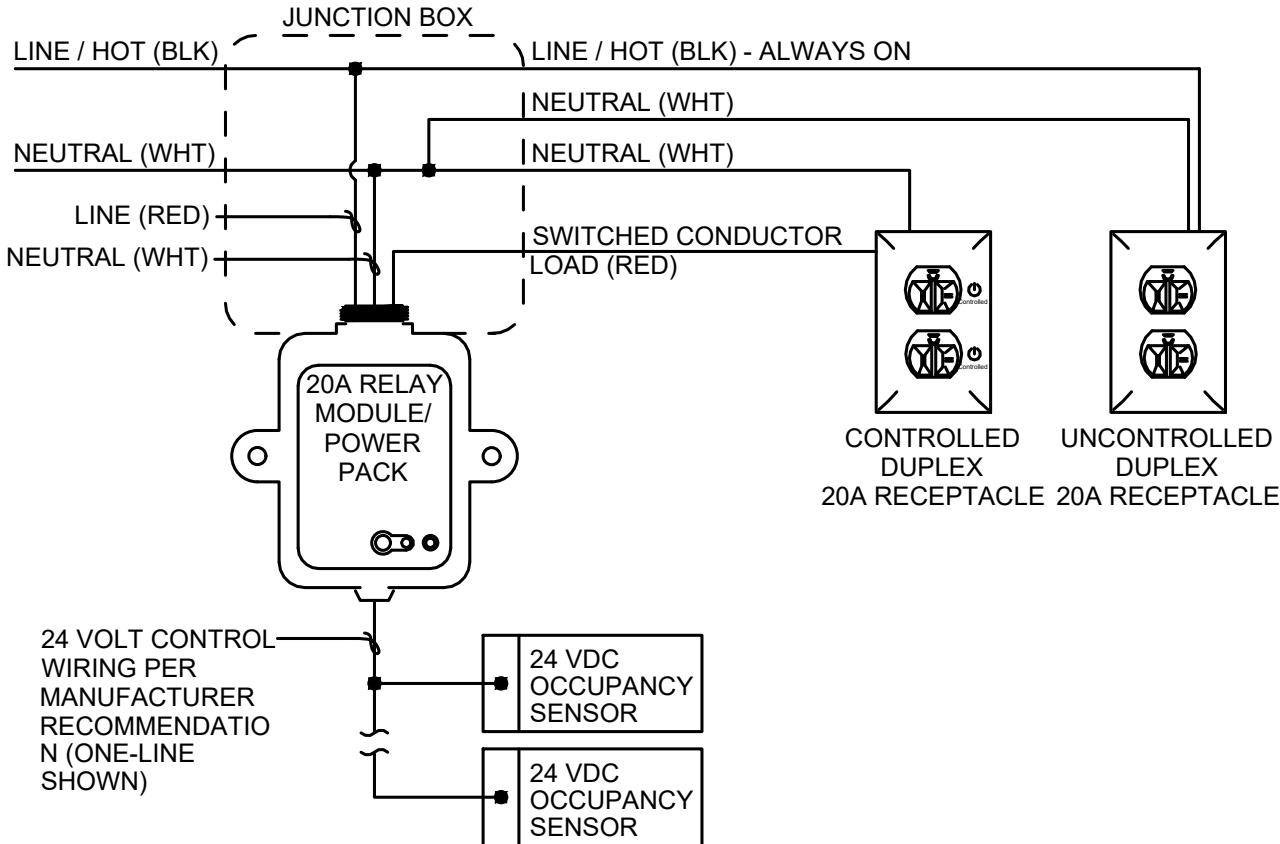

FULL RECEPTACLE CONTROL

SCALE: NONE


2

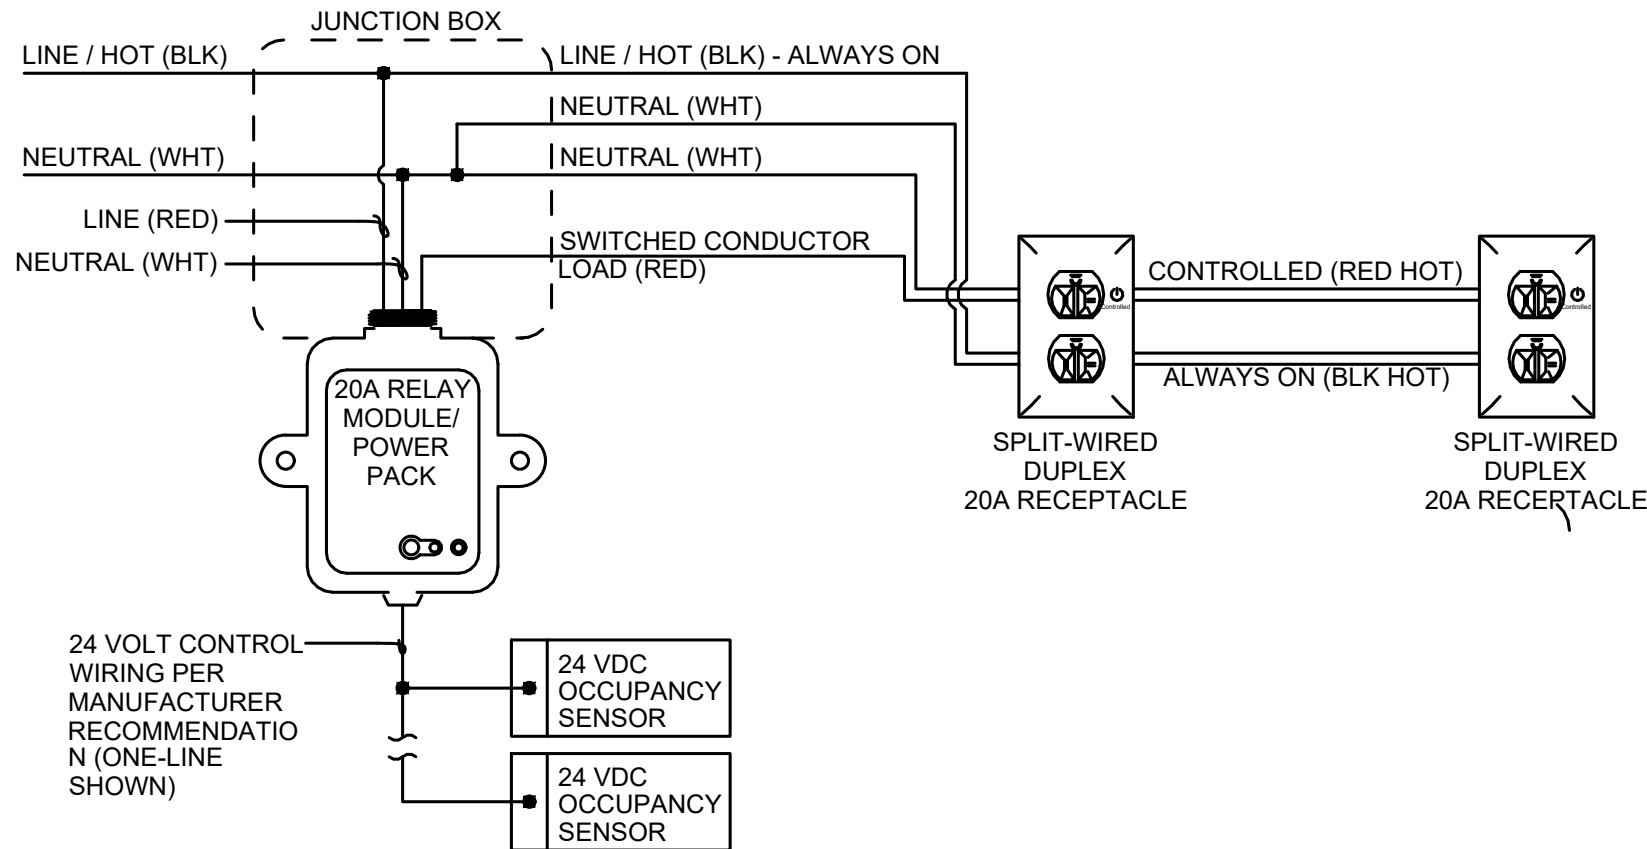

SPLIT-WIRED RECEPTACLE CONTROL

SCALE: NONE

3

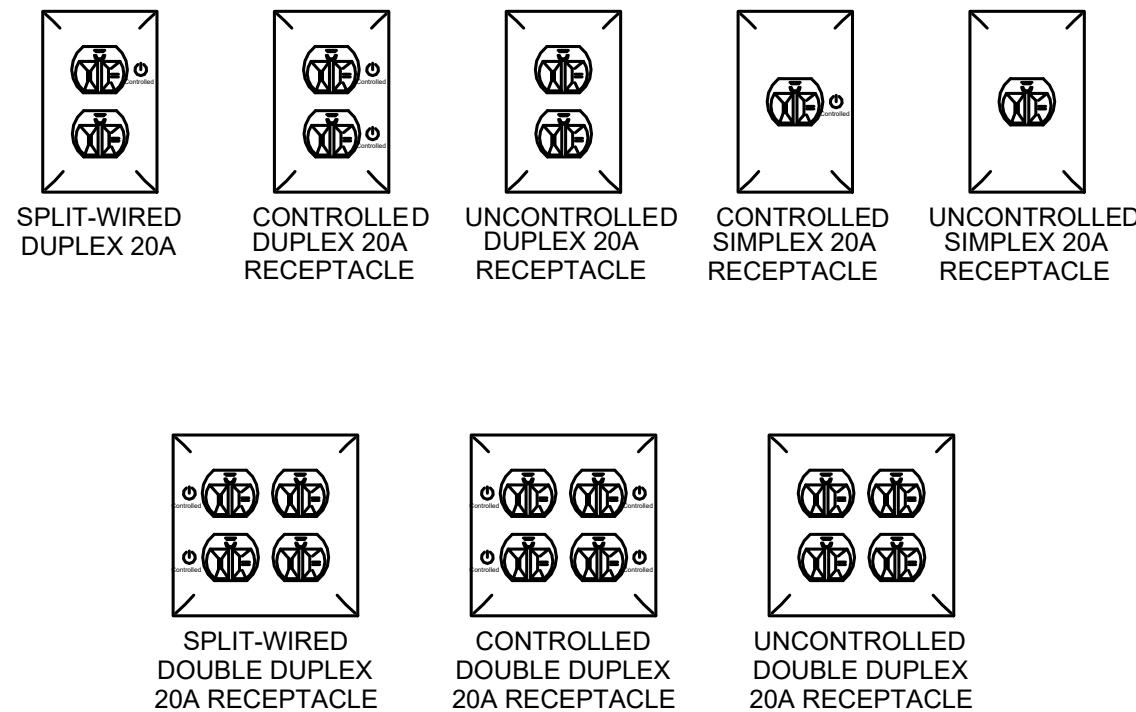

RECEPTACLE CONTROL SCHEMES

SCALE: NONE

4



ARCHITECTURE PLANNING INTERIOR DESIGN
15810 PARK TEN PLACE, SUITE 300
HOUSTON, TEXAS 77084
713-465-4650
www.sligroup.com

© COPYRIGHT

ALBA BANK
11700 Katy Freeway
Suite 175
Houston TX 77079

E/P/E PROJECT NUMBER : 26098.00

ISSUED FOR CLIENT APPROVAL DATE 06/24/2026

ISSUED FOR BIDDING 06/24/2026

ISSUED FOR PERMIT 06/24/2026

ISSUED FOR CONSTRUCTION

REVISIONS

MARK	DESCRIPTION	DATE
	PERMIT AND CONSTRUCTION SET	06/24/2026


The information, ideas, designs, details, layouts, techniques, features, arrangements, plans, sequences, dimensions, allowances, tolerances, conceptions, specifications, intentions, technology or embodiments, as illustrated, arranged, displayed, noted, recorded, indicated, represented, disclosed, evidenced, detailed or otherwise reduced to tangible form hereon, either expressly, inherently or by implication, are the confidential and proprietary information of SLI Design, Inc., and shall not be used for any purpose other than the specific project or undertaking identified on the drawing title block or legend for which they are and have been prepared by SLI Design, Inc. Any other reproduction, disclosure or use of any portion of the confidential and proprietary information of SLI Design, Inc., shall be a breach of the obligation of confidence created by the acceptance of this drawing from SLI Design, Inc. for a specific project or Contract. Any copying, duplicating, reproducing, utilization, alteration, modification, revision or change to this drawing, is expressly prohibited unless done with the prior written consent or approval of SLI Design, Inc., and shall not be undertaken without receipt of such prior written approval. This drawing is loaned by SLI Design, Inc., for the limited purpose of complying with a specific Contract. The drawing remains the property of SLI Design, Inc., and shall be returned upon request or completion of the contract, unless specifically authorized by Contract, under which it was loaned.

DESIGN TEAM
PM: JG
MECHANICAL: CC
PLUMBING: CC
ELECTRICAL: JG
CHECKED-BY: JG

DRAWING TITLE
ELECTRICAL DETAILS

SHEET NO.

E3.01

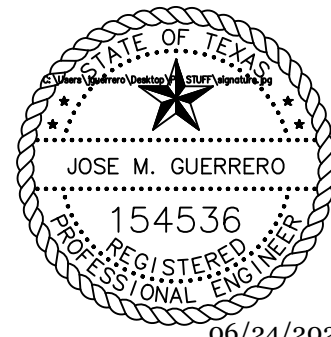

06/24/2026
EIBE Mechanical
Electrical
Consulting Engineers
Plumbing
12803 Southwest Frwy, Ste 170, Stafford, Tx 77477
Tel: (713) 840-0177 / Firm Reg. No: 5638