

National Bank & Trust - Bastrop

264 FM 969 BLDG. 3
BASTROP, TX 78602



ARCHITECTURE | DESIGN | CONSTRUCTION

15810 PARK TEN PLACE, SUITE 300
HOUSTON, TEXAS 77084
713-465-4650
www.sligroup.com

© COPYRIGHT




Project Number : 8989

SEPTEMBER 11,2026: ISSUED FOR BID AND PERMIT

RENDERING



VICINITY MAP

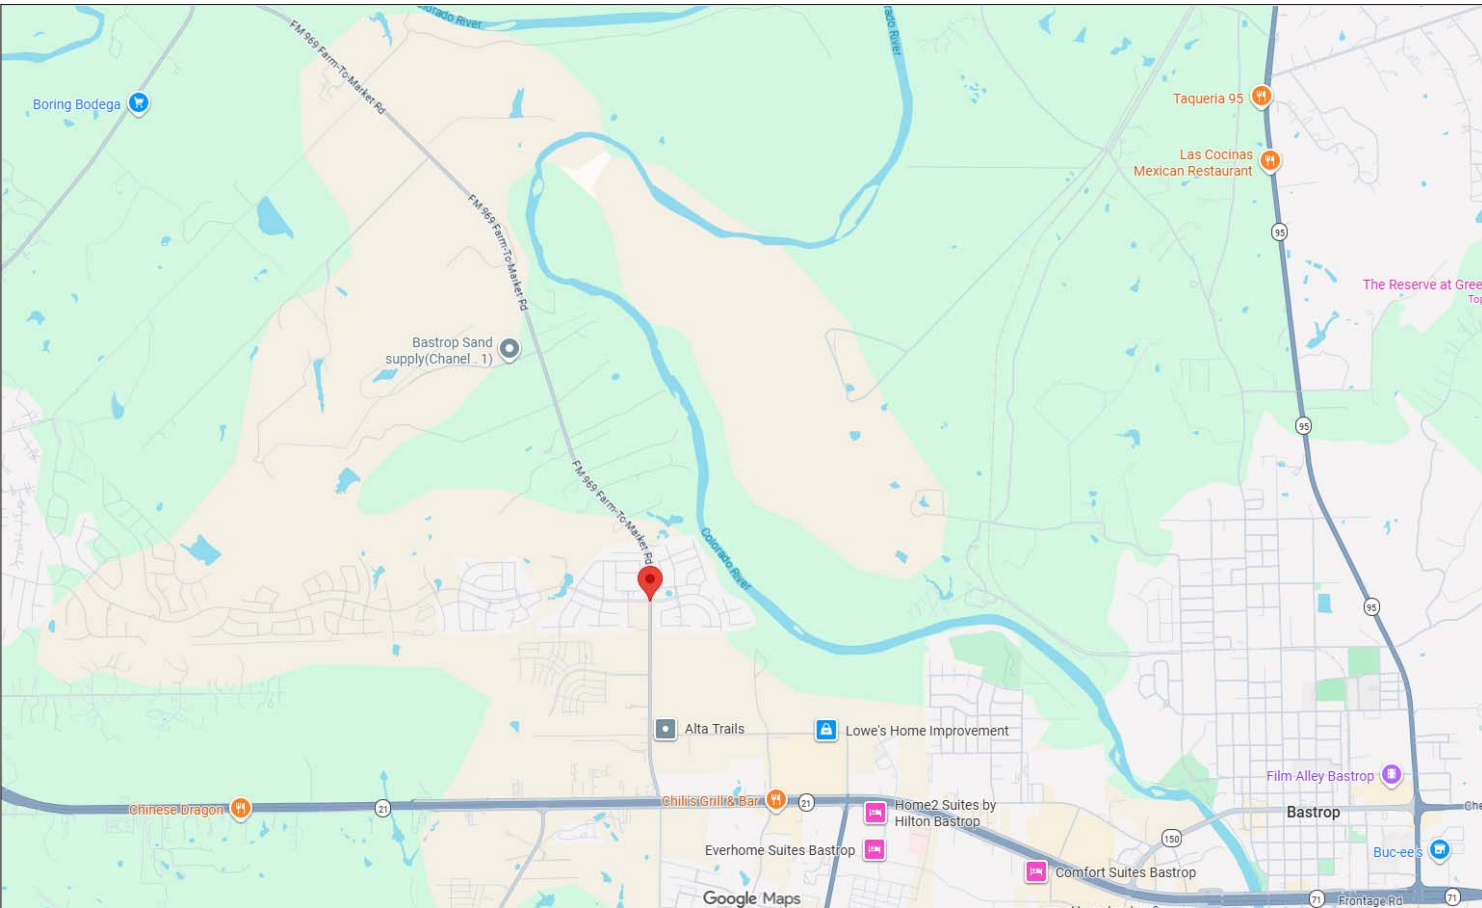

GENERAL

- T-1.00 TITLE SHEET
- T-1.10 GENERAL NOTES
- T-1.20 BUILDING ENVELOPE ANALYSIS
- T-1.30 FIRE APPARATUS SITE ACCESS PLAN
- T-1.40 LIFE SAFETY PLAN

CIVIL

- C-1 COVER SHEET
- C-2 GENERAL & CONSTRUCTION NOTES
- C-3 FINAL PLAT (1 OF 2)
- C-4 FINAL PLAT (2 OF 2)
- C-5 EROSION CONTROL PLAN
- C-6 EROSION CONTROL NOTES & DETAILS
- C-7 SITE PLAN
- C-8 UTILITIES PLAN
- C-9 STORM SEWER PLAN
- C-10 GRADING PLAN
- C-11 DRAINAGE PLAN
- C-12 PAVEMENT PLAN
- C-13 CONSTRUCTION DETAILS (1 OF 2)
- C-14 CONSTRUCTION DETAILS (2 OF 2)
- C-15 WATER DETAILS
- C-16 WASTEWATER DETAILS

ARCHITECTURAL SITE

- SP-1.00 OVERALL DEVELOPMENT SITE PLAN
- SP-1.10 SITE PLAN
- SP-2.10 SITE PLAN DETAILS
- SP-2.20 SITE PLAN DETAILS
- SP-2.30 SITE PLAN DETAILS
- L1 LANDSCAPE PLAN
- L2 LANDSCAPE PLAN
- IR1 IRRIGATION CONCEPT

ARCHITECTURAL

- A-0.00 ACCESSIBILITY ROUTE COMPLIANCE
- A-0.10 ACCESSIBILITY ELEMENT COMPLIANCE
- A-1.00 FLOOR PLAN
- A-1.10 FLOOR PLAN-ANNOTATION
- A-1.20 ENLARGED PLAN DETAILS
- A-1.30 PLAN DETAILS
- A-1.40 PLAN DETAILS
- A-2.00 DOOR SCHEDULE
- A-2.10 WINDOW SCHEDULE
- A-3.00 INTERIOR PARTITIONS
- A-4.00 RCP
- A-4.10 ATTIC PLATFORM
- A-4.20 CEILING DETAILS
- A-5.00 ROOF PLAN
- A-5.10 ROOF DETAILS
- A-6.00 EXTERIOR BUILDING ELEVATIONS
- A-6.10 EXTERIOR BUILDING ELEVATIONS
- A-7.00 BUILDING SECTIONS
- A-7.10 BUILDING SECTIONS
- A-8.00 WALL SECTIONS
- A-8.10 WALL SECTIONS
- A-9.00 EXTERIOR TRIMS
- A-9.10 TYP. DETAILS
- A-10.00 INTERIOR ELEVATIONS
- A-10.01 INTERIOR ELEVATIONS
- A-11.00 MILLWORK DETAILS

ARCHITECTURAL

- A-11.01 INTERIOR TRIM/MOLDING
- A-12.00 FINISHED FLOOR
- A-12.01 BANK EQUIPEMENT
- A-12.02 RESTROOM ACCESSORIES
- A-13.00 POWER PLAN
- A-14.00 INTERIOR SIGNAGE
- A-14.10 EXTERIOR SIGNAGE

STRUCTURAL

- S000 GENERAL NOTES
- S001 GENERAL NOTES
- S002 GENERAL NOTES
- S003 TESTING AND INSPECTIONS
- S101 FOUNDATION PLAN
- S201 ROOF FRAMING PLAN
- S202 HIGH ROOF FLOOR FRAMING PLAN
- S301 FOUNDATION DETAILS
- S302 TYPICAL FOUNDATION DETAILS
- S401 FRAMING DETAILS
- S402 FRAMING DETAILS
- S403 FRAMING DETAILS

MEP

- MEP-1.00 MEP SPECIFICATIONS
- MEP-2.00 MEP SPECIFICATIONS
- MEP-3.00 MEP SPECIFICATIONS
- MEP-4.00 MEP SITE PLAN
- M-0.10 MECHANICAL INFORMATION
- M-1.10 MECHANICAL PLAN
- M-2.10 MECHANICAL DETAILS
- E-0.10 ELECTRICAL INFORMATION
- E-1.10 ELECTRICAL LIGHTING PLAN
- E-2.10 ELECTRICAL POWER PLAN
- E-3.10 ELECTRICAL PLAN - ATTIC
- E-4.10 ELECTRICAL SCHEDULES
- E-5.10 ELECTRICAL DETAILS
- E-6.10 GENERATOR SPECIFICATIONS
- E7.10 INTERIOR LIGHTING PHOTOMETRICS
- E8.10 EXTERIOR LIGHTING PHOTOMETRICS
- P-0.10 PLUMBING INFORMATION
- P-1.10 PLUMBING PLAN
- P-2.10 PLUMBING SPEC SHEETS
- P-2.20 PLUMBING SPEC SHEETS
- P-3.10 PLUMBING DETAILS
- P-4.10 PLUMBING RISERS

PLUMBING FACILITIES

	REQUIRED	PROVIDED
WATER CLOSETS FOR MEN PER FLOOR:	1	1
WATER CLOSETS FOR WOMEN PER FLOOR:	1	1
LAVATORIES FOR MEN PER FLOOR:	1	1
LAVATORIES FOR WOMEN PER FLOOR:	1	1

PROJECT TEAM

ARCHITECT/CONTRACTOR
SLI GROUP
15810 PARK TEN PLACE, SUITE 300
HOUSTON, TEXAS 77084
713-465-4650

STRUCTURAL ENGINEER
CJG Engineers - Houston LLC
6051 North Course Drive, Suite 375
Houston, Texas 77072

CIVIL ENGINEER
CARLSON BRIGANCE & DOERING, INC.
5701 W. William Cannon Drive
Austin, TX 78749

MEP ENGINEER
E|B|E, Inc.
12603 Southwest Freeway, Suite 170
Stafford, TX 77477

SURVEYOR

Thompson Engineering
10665 Richmond Avenue
Building Five, Suite 192
Houston, Texas 77042

GEOTECHNICAL

ABBREVIATIONS

ABBR	DEFINITION	ABBR	DEFINITION
AC	AIR CONDITIONER	INCL	INCLUDING
ACT	ACOUSTICAL CEILING TILE	INS	INSULATION
ADD	ADDITIONAL	INT	INTERIOR
ADJ	ADJACENT	JAN	JANITOR
AFF	ABOVE FINISH FLOOR	JC	JANITOR'S CLOSET
AFC	AT FINISH CEILING	JT	JOINT
ALUM	ALUMINUM	LP	LOW POINT
ARCH	ARCHITECTURAL	LAM	LAMINATED
BD	BOARD	LAV	LAVATORY
BFF	BELOW FINISH FLOOR	LGT	LIGHTING
BLDG	BUILDING	MAX	MAXIMUM
BLKG	BLOCKING	MBM	METAL BUILDING MANUFACTURER
BM	BEAM	MECH	MECHANICAL
BO	BOTTOM OF	MEMB	MEMBRANE
BRG	BEARING	MFR	MANUFACTURER
CBD	CHALKBOARD	MIN	MINIMUM
CI	CAST IRON	MISC	MISCELLANEOUS
CIP	CAST-IN-PLACE	MO	MASONRY OPENING
CJ	CONTROL JOINT	MTL	METAL
CL	CENTERLINE	NIC	NOT IN CONTRACT
CLR	CLEAR	NO	NO
CLR	CLEAR	NTS	NOT TO SCALE
CLO	CLOSET	OC	ON CENTER
CMU	CONCRETE MASONRY UNIT	QHD	OVERHEAD DOOR
CONT	COLUMN	OPNG	OPENING
CONC	CONCRETE	OPP	OPPOSITE
CONT	CONTRIBUTUS	OPP HD	OPPOSITE HAND
CPT	CARPET	PART	PARTITION
CT	CERAMIC TILE	PC	PRECAST
DET	DETAIL	PEMB	PRE-ENGINEERED METAL BUILDING
DF	DRINKING FOUNTAIN	PLAM	PLASTIC LAMINATE
DN	DOWN	PT	PRESSURE TREATED
DN	DOWN	PTD	PAINTED
DR	DOOR	PVC	POLYVINYL CHLORIDE
DWG	DRAWING	QT	QUARRY TILE
EA	EACH	QTY	QUANTITY
EJ	EXPANSION JOINT	R	RADIUS or RISER
ELEC	ELECTRICAL	RA	RETURN AIR
ELEV	ELEVATION or ELEVATOR	RD	ROOF DRAIN
EXT	EXTERIOR	REF	REFERENCE
EQ	EQUAL	REF	REINFORCING or REINFORCED
EQUIP	EQUIPMENT	REQ	REQUIRED
EXIST	EXISTING	REV	REVISION
FD	FLOOR DRAIN	RTU	ROUGH OPENING
FD	FOUNDATION	RTU	ROUGH OPENING
FE	FIRE EXTINGUISHER	SECT	SECTION
FEC	FIRE EXTINGUISHER CABINET	SIM	SIMILAR
FF	FINISH FLOOR	SPEC	SPECIFICATION
FFE	FINISH FLOOR ELEVATION	SQ	SQUARE
FFT	FINISH FLOOR TRANSITION	SSTL	STAINLESS STEEL
FIN	FINISH	STD	STANDARD
FIXT	FIXTURE	STL	STEEL
FR	FIRE-RATED	STRUC	STRUCTURAL
FRP	FIBERGLASS REINFORCED PLASTIC	SUSP	SUSPENDED
FT	FOOT	TREAD	TREAD
FV	FIELD VERIFY	TBD	TO BE DETERMINED or TACKBOARD
GA	GALVANIZED	TDC	TRENCH DRAIN
GALV	GALVANIZED	TO	TO
GC	GENERAL CONTRACTOR	TOP OF	TOP OF
GL	GLASS	TOP OF CONCRETE	TOP OF CONCRETE
GYP BD	GYPNUM BOARD	TOS	TOP OF STEEL
HC	HANDICAP ACCESSIBLE	TOW	TOP OF WALL
HDW	HARDWARE	THK	THICK
HGT	HEIGHT	TYP	TYPICAL
HM	HOLLOW METAL	UNO	UNLESS NOTED OTHERWISE
HORIZ	HORIZONTAL	VERT	VINYL COMPOSITION TILE
HP	HIGH POINT	WD	WOOD
HVAC	HEATING, VENTILATION, AND AIR CONDITIONING	WIDW	WIDE FLANGE
IN	INCH	WPR	WATERPROOFING

DRAWING SYMBOLS LEGEND

SYMBOLS	DESCRIPTION	SYMBOLS	DESCRIPTION	SYMBOLS	DESCRIPTION
	NORTH ARROW		PARTITION TYPE		COLUMN GRID
	DRAWING NAME, NUMBER, AND SCALE		WINDOW TYPE		CENTERLINE
	ENLARGED DETAIL REFERENCE		DOOR IDENTIFICATION		BREAK LINE
	EXTERIOR ELEVATION		ROOM NAME ROOM NUMBER		SPOT ELEVATION
	BUILDING SECTION		INTERIOR ELEVATION		
	WALL SECTION		DIMENSION LINES		
	SECTION DETAIL		MATCH LINE		
	VERTICAL ELEVATION		REVISION NUMBER & AFFECTED AREA		
			FIRE EXTINGUISHER		

TYPICAL MOUNTING HEIGHTS:

CONVENIENCE OUTLETS	15" (FLOOR TO BOTTOM OF BOX UNLESS OTHERWISE NOTED ON PLAN)
LIGHT SWITCHES	45" (FLOOR TO BOTTOM OF BOX)
FIRE ALARM PULL STATIONS	48" (FLOOR TO BOTTOM OF PULL)
TELEPHONE OUTLETS	15" (FLOOR TO BOTTOM OF BOX OR AS NOTED ON PLAN)
WALL TELEPHONE OUTLETS	45" (FLOOR TO BOTTOM OF BOX)
DATA CABLE OUTLETS	15" (FLOOR TO BOTTOM OF BOX)
SMOKE AND HEAT DETECTORS	CEILING MOUNTED

GENERAL NOTES:

1. NOTIFY ARCHITECT OF ANY DISCREPANCIES AND/OR OMISSIONS.
2. ALL WORK SHALL COMPLY WITH ALL FEDERAL, STATE, AND LOCAL ORDINANCES.
3. ALL DIMENSIONS ARE TO FINISHED FACE OF PARTITIONS.
4. ALL DOORS ON AN ACCESSIBLE ROUTE SHALL HAVE A MIN. 18" CLEAR ON THE PULL SIDE, A MIN. 12" CLEAR ON THE PUSH SIDE WHEN DOOR IS EQUIPPED WITH BOTH A LATCH AND CLOSER.
5. ALL DOORS TO RECEIVE NEW AMERICAN DISABILITIES ACT COMPLIANT HARDWARE.