

OCCUPANT LOAD FOR					
Number	Name	Occupancy	Area	Occupant Factor	Occupancy Load
100	LOBBY	BUSINESS	587 SF	150	4
102	MANAGER	BUSINESS	226 SF	150	2
103	TELLER	BUSINESS	266 SF	150	2
104	CASH ROOM	BUSINESS	108 SF	150	1
105	CEO OFFICE	BUSINESS	150 SF	150	2
106	DATA/ELEC.	ACCESSORY	95 SF	300	1
108	MEN	BUSINESS	59 SF	0	
109	WOMEN	BUSINESS	59 SF	0	
110	JANITOR	ACCESSORY	18 SF	300	1
111	CORRIDOR	CIRCULATION	190 SF	0	
112	STORAGE	STORAGE	79 SF	300	1
113	BREAK ROOM	ACCESSORY	135 SF	150	1
114	WORKROOM	ACCESSORY	58 SF	300	1
115	ATM	STORAGE	50 SF	300	1
116	OFFICE	BUSINESS	129 SF	150	1
117	PERSONAL BANKER	BUSINESS	129 SF	150	1
118	LOAN OFFICER	BUSINESS	226 SF	150	2
124	Room		Not Placed		
			2566 SF		21

LIFE SAFETY:

NOTE:
FIRE EXTINGUISHER: FE
FIRE EXTINGUISHER SPEC: CLASS A, 10LBS
HT SERIES-HALOTRON I - HT11
FIRE EXTINGUISHER CABINET SPEC:
LARSEN AL2712-RM
AED SPEC: PHILIPS AA-M5066A-WC280-100-SL-A
AED CABINET SPEC: LARSEN S1414-RD

EMERGENCY LIGHTING: REF. SHEET E-2.1 & E-2.2
EXIT SIGNS: REF. SHEET E-2.1 & E-2.2
SMOKE DETECTORS: REF. SHEET MEP
PANIC HARDWARE: REF. SHEET A-2.00

GENERAL NOTES


1. REFER TO ELECTRICAL DRAWINGS FOR LOCATIONS AND QUANTITY OF SMOKE DETECTORS AND ILLUMINATED EXIT SIGNS.
2. REFER TO A-3.00 FOR COMPOSITION OF RATED PARTITIONS.
3. REFER TO A-2.00 FOR DOOR SCHEDULE IDENTIFYING FIRE RATING RATINGS
4. IF AN OPENING OCCURS IN A RATED WALL, REFER TO THE SPECIFICATIONS FOR REQUIREMENTS.
5. FIRE ALARM SYSTEM WILL REQUIRE SEPARATE PERMIT AND SUBMITTAL. ISSUANCE OF A BUILDING PERMIT DOES NOT IMPLY APPROVAL TO INSTALL THE FIRE ALARM SYSTEM. SYSTEM SHALL BE INSTALLED IN ACCORDANCE WITH NFPA STANDARD 14 AND THE COUNTY FIRE MARSHALL.
6. ALL EXITS SHALL COMPLY WITH ACCESSIBLE STANDARDS AND DISCHARGE TO A PAVED PUBLIC WAY, OR A PAVED SIDEWALK WHICH LEADS TO A PUBLIC WAY.
7. BUILDING WILL BE CONSTRUCTED IN ACCORDANCE WITH THE CITY FIRE CODE AND REFERENCED DOCUMENTS.

APPLICABLE CODES

2015 IBC WITH CITY OF HOUSTON AMENDMENTS
2020 NEC WITH CITY OF HOUSTON AMENDMENTS
2015 UPC WITH CITY OF HOUSTON AMENDMENTS
2015 IFC WITH CITY OF HOUSTON AMENDMENTS
2015 IECC WITH CITY OF HOUSTONAMENDMENTS
2015 UMC WITH CITY OF HOUSTON AMENDMENTS
2012 TAS TEXAS ACCESSIBILITY STANDARDS (ADOPTED MARCH
2012)

LEGEND

- | | |
|---|---|
|  | NEW PARTITION NON-RATED
RE: A-3.0 FOR PARTITION TYPES |
|  | LONGEST EXIT ROUTE PER LEVEL |
|  | EXIT ROUTE |
|  | EXIT POINT WITH WIDTH INDICATED IN INCHES
OCCUPANT LOAD SHOWN VERTICALLY
P-PROVIDED EXIT WIDTH OF EGRESS COMPONENT
R-REQUIRED EXIT WIDTH OF EGRESS COMPONENT |
|  | FIRE EXTINGUISHER CABINET &
FIRE EXTINGUISHER |
|  | AUTOMATED EXTERNAL DEFIBRILLATOR CABINET
& AUTOMATED EXTERNAL DEFIBRILLATOR |

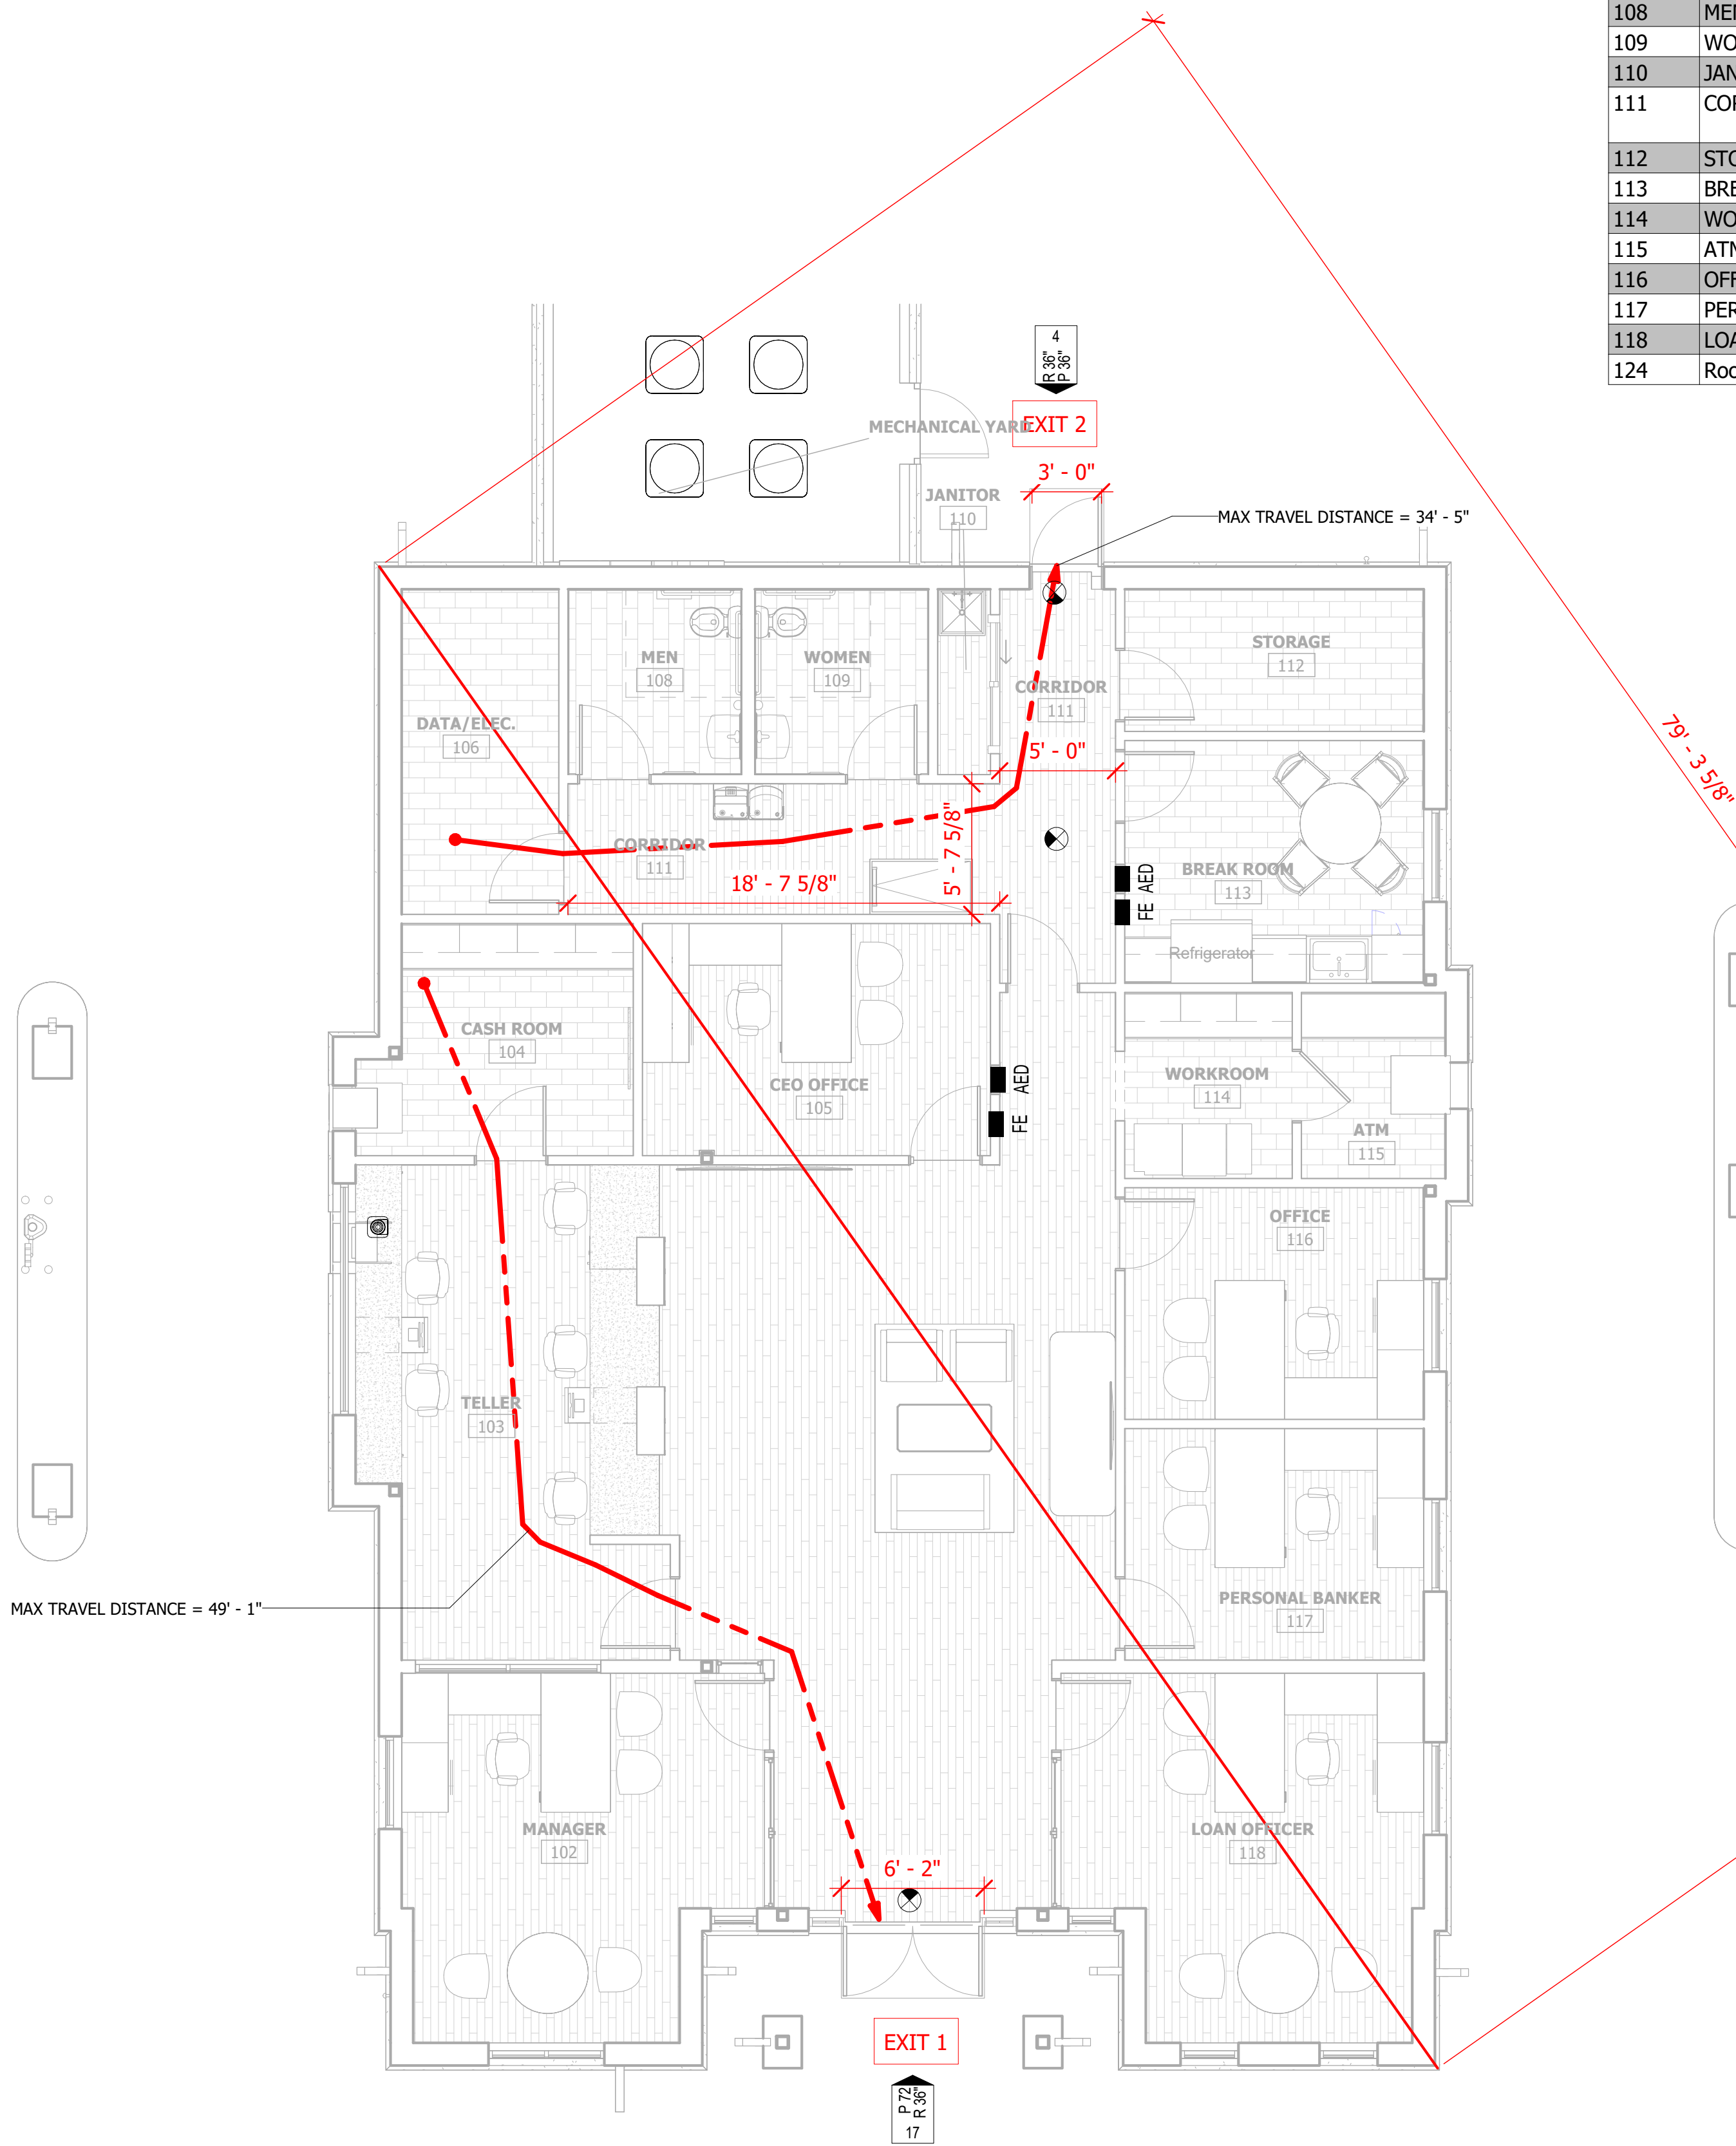

① LIFE SAFETY
 $3/16'' = 1'-0''$



ARCHITECTURE | DESIGN | CONSTRUCTION

15810 PARK TEN PLACE, SUITE 300
HOUSTON, TEXAS 77084
713-465-4650
www.sligroup.com

NBT
National Bank & Trust
National Bank & Trust - Bastrop

264 FM 969 BLDG. 3
BASTROP, TX 78602

Project Number : 8989

	DATE
ISSUED FOR CLIENT APPROVAL	08.17.2026
ISSUED FOR BIDDING	09.11.2026
ISSUED FOR PERMIT	09.11.2026
ISSUED FOR CONSTRUCTION	

REVISIONS

[illegible]

The information, ideas, designs, details, layouts, techniques, features, arrangements, plans, sequences, dimensions, allowances, tolerances, concepts, specifications, instructions, drawings, data, notes, calculations, drawings, drawings, employed, notes, records, indicated, represented, disclosed, expressed, detailed or otherwise reduced to tangible form herein, either expressly, inherently or by implication, are the confidential and proprietary information of SLL Design, Inc., and shall be held in confidence by the recipient of this information, and shall be identified on the drawing title block or legend for which they are and have been prepared by SLL Design, Inc. Any other reproduction, disclosure or use of any portion of the confidential and proprietary information of SLL Design, Inc., shall be a breach of this Agreement, and shall constitute a violation of the terms of this SLL Design, Inc. for a specific project or Contract. Any copying, duplicating, reproducing, utilization, alteration, modification, revision or change to this drawing, is expressly prohibited, unless done with the prior written consent or approval of SLL Design, Inc. SLL Design, Inc. shall not be responsible for any unauthorized use or approval. This drawing is loaned by SLL Design, Inc., for the limited purpose of complying with a specific Contract. The drawing remains the property of SLL Design, Inc. and shall not be used for any other purpose without the written consent, specifically authorized by Contract, under which it was loaned.

PRINT DATE: 9/11/2026 9:07:42 AM



09/11/20

DRAWING TITLE

LIFE SAFETY PLAN

DRAWN BY

SHEET NO.

CHECKED BY

CA

T-1.40