



ARCHITECTURE | DESIGN | CONSTRUCTION

15810 PARK TEN PLACE, SUITE 300
HOUSTON, TEXAS 77084
713-465-4650
www.sligroup.com

© COPYRIGHT


NBT
National Bank & Trust
National Bank & Trust - Bastrop
Enter address here

E/BE Project Number : 26129.00

ISSUED FOR CLIENT APPROVAL	DATE
ISSUED FOR BIDDING	09/11/26
ISSUED FOR PERMIT	09/11/26
ISSUED FOR CONSTRUCTION	

REVISIONS		
MARK	DESCRIPTION	DATE
	70% REVIEW SET	07/29/26
	90% REVIEW SET	08/20/26
	ISSUE FOR PERMIT & BID	09/11/26

The information, ideas, designs, details, layouts, techniques, features, arrangements, plans, sequences, dimensions, allowances, tolerances, conceptions, specifications, intentions, technology or embodiments, as illustrated, arranged, displayed, noted, recorded, indicated, represented, disclosed, evidenced, detailed or otherwise reduced to tangible form hereon, either expressly, inherently or by implication, are the confidential and proprietary information of SLI Design, Inc., and shall not be used for any purpose other than the specific project or undertaking identified on the drawing title block or legend for which they are and have been prepared by SLI Design, Inc. Any other reproduction, disclosure or use of any portion of the confidential and proprietary information of SLI Design, Inc., shall be a breach of the obligation of confidence created by the acceptance of this drawing from SLI Design, Inc. for a specific project or Contract. Any copying, duplicating, reproducing, utilization, alteration, modification, revision or change to this drawing, is expressly prohibited unless done with the prior written consent or approval of SLI Design, Inc., and shall not be undertaken without receipt of such prior written approval. This drawing is loaned by SLI Design, Inc., for the limited purpose of complying with a specific Contract. The drawing remains the property of SLI Design, Inc., and shall be returned upon request or completion of the contract, unless specifically authorized by Contract, under which it was loaned.

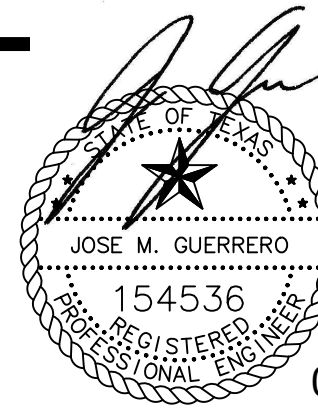


09/11/2026

DRAWING TITLE
ELECTRICAL LIGHTING PLAN
SHEET NO.

E-1.10

E/B/E Mechanical
Electrical
Plumbing
12603 Southwest Fwy, Ste 170, Stafford, Tx 77477
Tel: (713) 840-0177 / Firm Reg. No: 5638

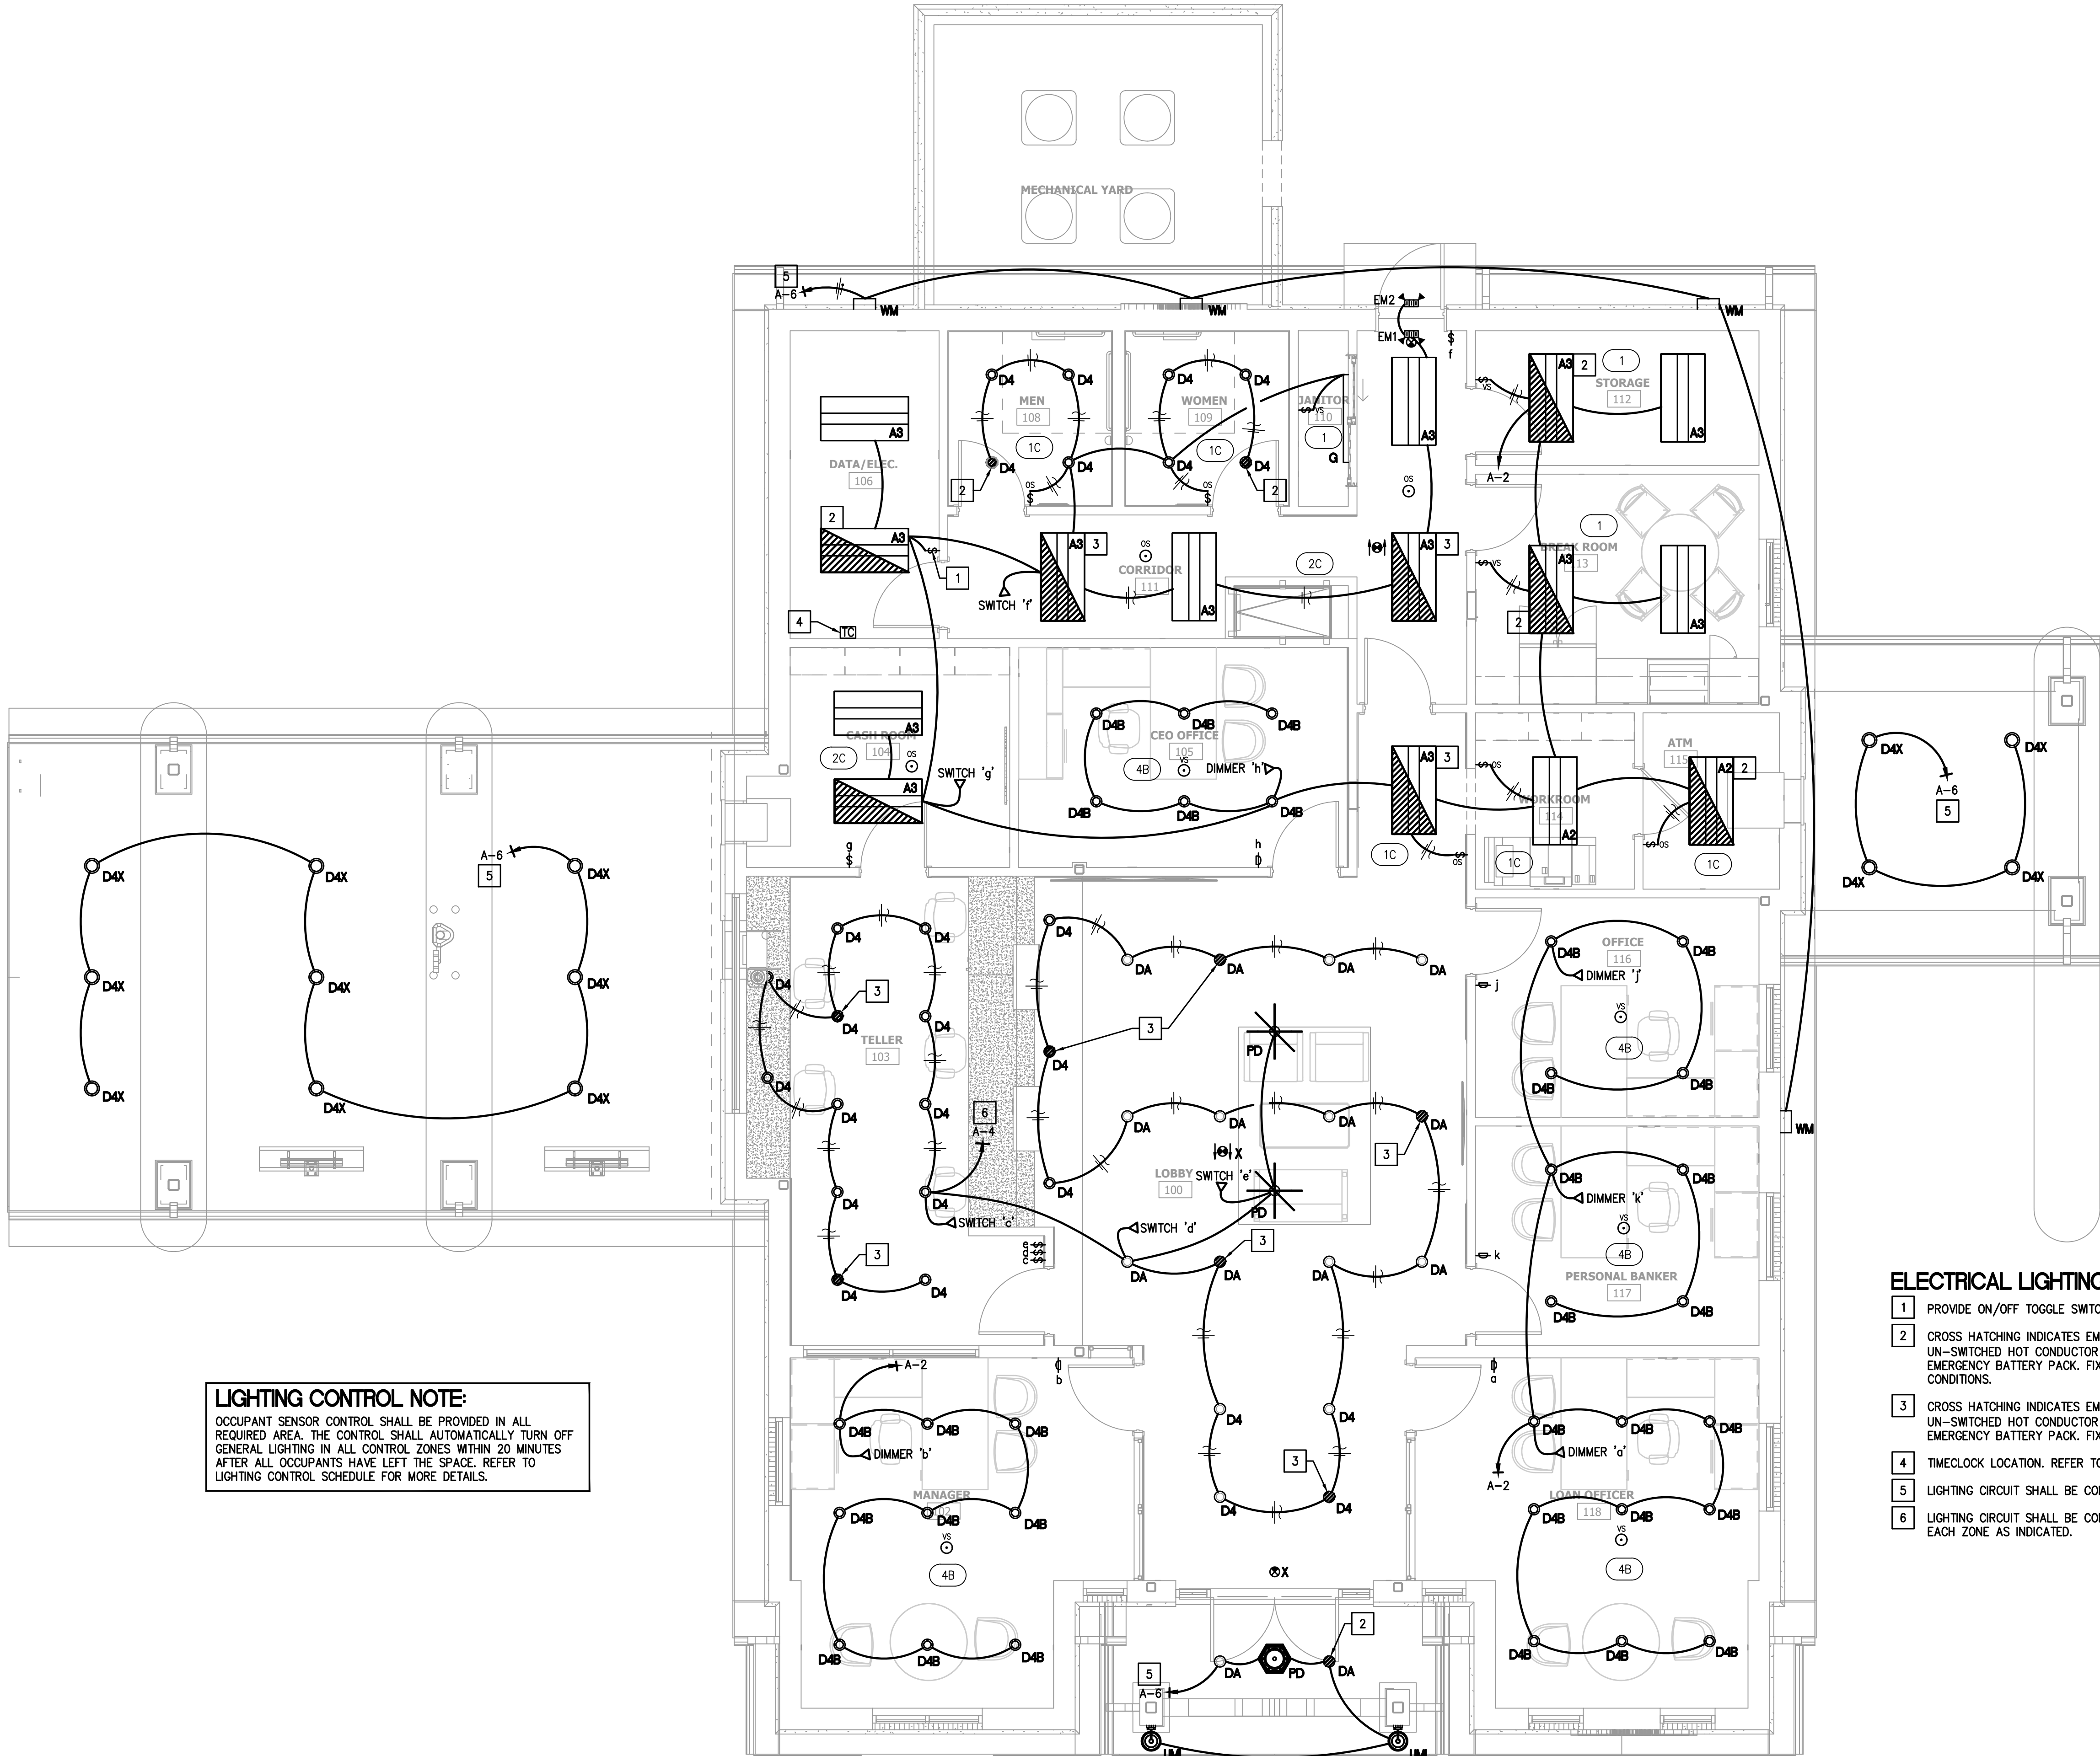

LIGHTING CONTROL NOTE:
OCCUPANT SENSOR CONTROL SHALL BE PROVIDED IN ALL REQUIRED AREA. THE CONTROL SHALL AUTOMATICALLY TURN OFF GENERAL LIGHTING IN ALL CONTROL ZONES WITHIN 20 MINUTES AFTER ALL OCCUPANTS HAVE LEFT THE SPACE. REFER TO LIGHTING CONTROL SCHEDULE FOR MORE DETAILS.

- ELECTRICAL LIGHTING KEYED NOTES:**
- 1 PROVIDE ON/OFF TOGGLE SWITCH AT THIS LOCATION.
 - 2 CROSS HATCHING INDICATES EMERGENCY LIGHTING. FIXTURE TO BE CONNECTED TO UN-SWITCHED HOT CONDUCTOR WITH 2#10, 1/2" C . PROVIDE FIXTURE WITH 90 MINUTE EMERGENCY BATTERY PACK. FIXTURE TO BE SWITCHED AS SHOWN UNDER NORMAL CONDITIONS.
 - 3 CROSS HATCHING INDICATES EMERGENCY LIGHTING. FIXTURE TO BE CONNECTED TO UN-SWITCHED HOT CONDUCTOR WITH 2#10, 1/2" C . PROVIDE FIXTURE WITH 90 MINUTE EMERGENCY BATTERY PACK. FIXTURE TO RUN CONTINUOUSLY AND UN-SWITCHED.
 - 4 TIMECLOCK LOCATION. REFER TO LIGHTING CONTROL NOTES FOR ADDITIONAL INFORMATION.
 - 5 LIGHTING CIRCUIT SHALL BE CONTROLLED BY PHOTOCELL RECEPTORS.
 - 6 LIGHTING CIRCUIT SHALL BE CONTROLLED BY TIME CLOCK. PROVIDE OVERRIDE SWITCH FOR EACH ZONE AS INDICATED.

01 ELECTRICAL LIGHTING PLAN
SCALE: 1/4"=1'-0"