



ARCHITECTURE | DESIGN | CONSTRUCTION

15810 PARK TEN PLACE, SUITE 300
HOUSTON, TEXAS 77084
713-465-4650
www.sligroup.com

© COPYRIGHT

NBT
National Bank & Trust
National Bank & Trust - Bastrop
Enter address here

E/BE Project Number : 26129.00

ISSUED FOR CLIENT APPROVAL	DATE
ISSUED FOR BIDDING	09/11/26
ISSUED FOR PERMIT	09/11/26
ISSUED FOR CONSTRUCTION	

MARK	DESCRIPTION	DATE
	70% REVIEW SET	07/29/26
	90% REVIEW SET	08/20/26
	ISSUE FOR PERMIT & BID	09/11/26


The information, ideas, designs, details, layouts, techniques, features, arrangements, plans, designs, dimensions, allowances, tolerances, conceptions, specifications, intentions, technology or embodiments, as illustrated, arranged, displayed, noted, recorded, indicated, represented, disclosed, evidenced, detailed or otherwise reduced to tangible form hereon, either expressly, inherently or by implication, are the confidential and proprietary information of SLI Design, Inc., and shall not be used for any purpose other than the specific project or undertaking identified on the drawing title block or legend for which they are and have been prepared by SLI Design, Inc. Any other reproduction, disclosure or use of any portion of the confidential and proprietary information of SLI Design, Inc., shall be a breach of the obligation of confidence created by the acceptance of this drawing from SLI Design, Inc. for a specific project or contract. Any copying, duplicating, reproducing, utilization, alteration, modification, revision or change to this drawing, is expressly prohibited unless done with the prior written consent or approval of SLI Design, Inc., and shall not be undertaken without receipt of such prior written approval. This drawing is loaned by SLI Design, Inc., for the limited purpose of complying with a specific contract. The drawing remains the property of SLI Design, Inc., and shall be returned upon request or completion of the contract, unless specifically authorized by contract, under which it was loaned.



09/11/2026

DRAWING TITLE
ELECTRICAL POWER PLAN
SHEET NO.

E-2.10

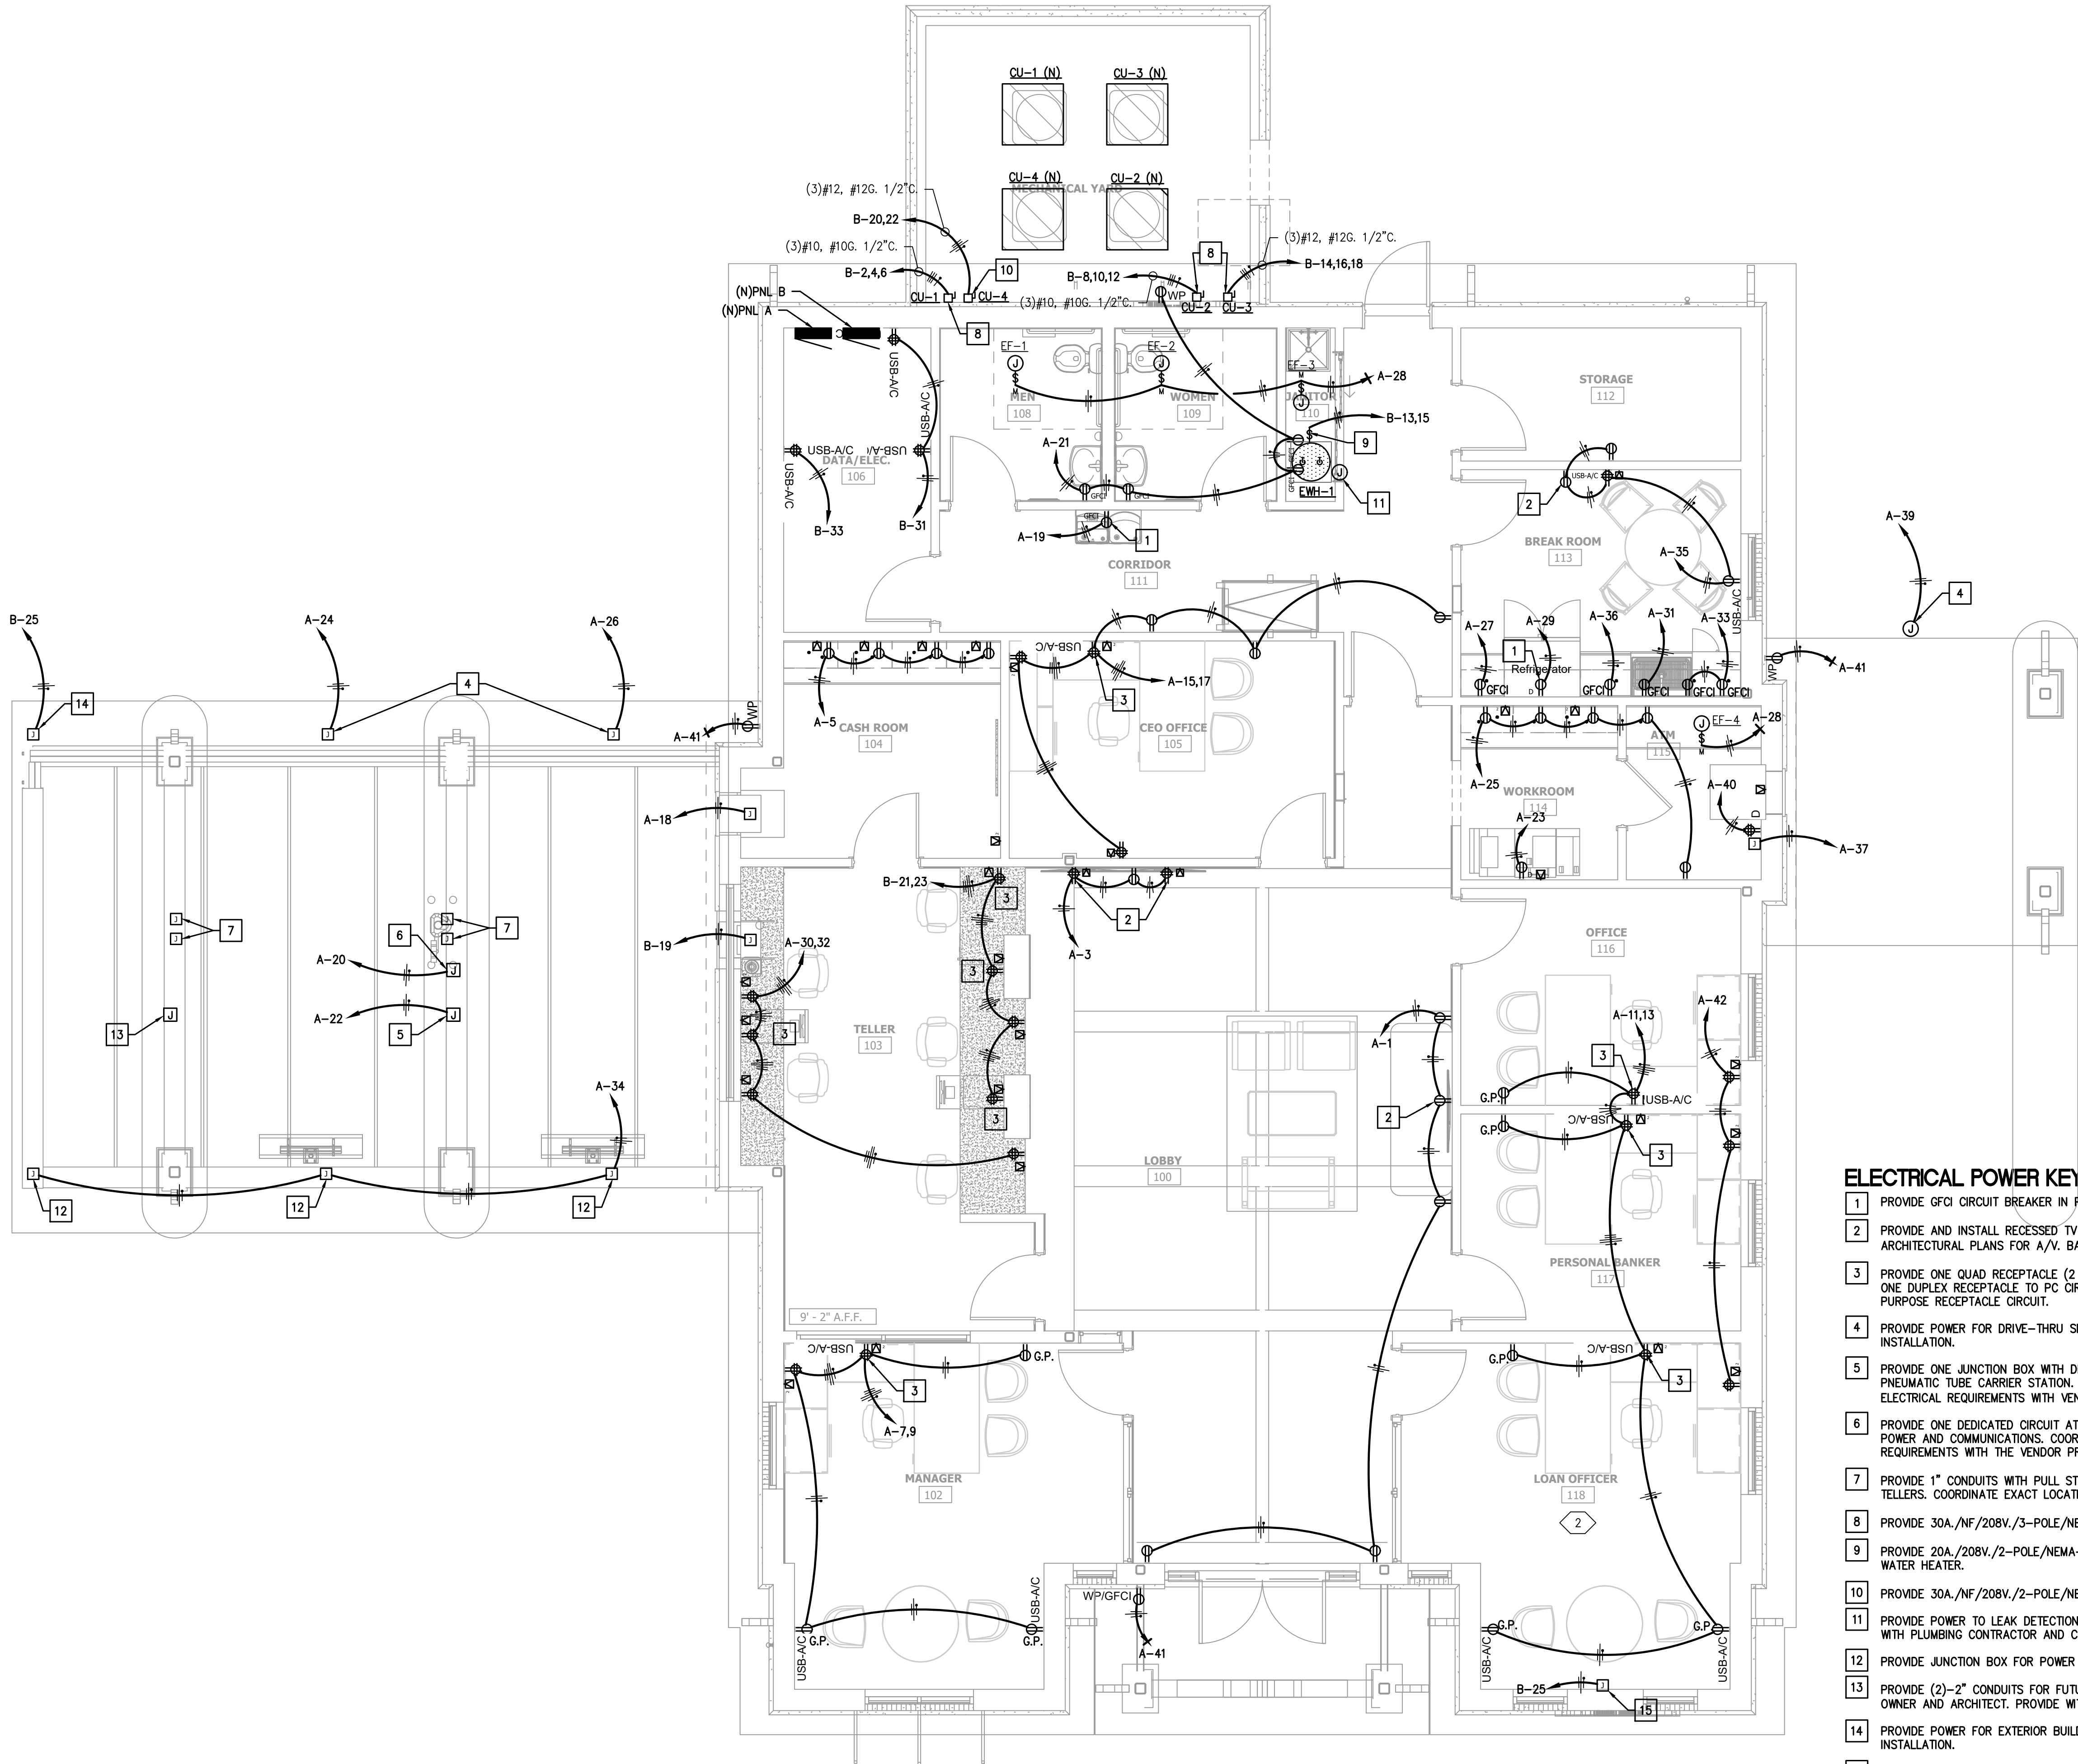

ELECTRICAL POWER KEYED NOTES:

- 1 PROVIDE GFCI CIRCUIT BREAKER IN PANEL BOARD.
- 2 PROVIDE AND INSTALL RECESSED TV OUTLET AT +60" A.F.F. THIS LOCATION. REFER TO ARCHITECTURAL PLANS FOR A/V, BACK BOX AND ADDITIONAL ROUGH-IN INFORMATION.
- 3 PROVIDE ONE QUAD RECEPTACLE (2 DUPLEX RECEPTACLES UNDER ONE COVER). CONNECT ONE DUPLEX RECEPTACLE TO PC CIRCUIT AND ONE DUPLEX RECEPTACLE TO GENERAL PURPOSE RECEPTACLE CIRCUIT.
- 4 PROVIDE POWER FOR DRIVE-THRU SIGN. VERIFY LOCATION WITH VENDOR PRIOR TO INSTALLATION.
- 5 PROVIDE ONE JUNCTION BOX WITH DEDICATED CIRCUIT ABOVE DRIVE-THROUGH CANOPY FOR PNEUMATIC TUBE CARRIER STATION. COORDINATE FINAL LOCATION, CONDUIT ROUTING, AND ELECTRICAL REQUIREMENTS WITH VENDOR'S APPROVED SHOP DRAWINGS.
- 6 PROVIDE ONE DEDICATED CIRCUIT AT DRIVE-THROUGH LANE TRANSACTION PEDESTAL FOR POWER AND COMMUNICATIONS. COORDINATE CONDUIT SIZE AND FINAL ROUGH-IN REQUIREMENTS WITH THE VENDOR PRIOR TO INSTALLATION.
- 7 PROVIDE 1" CONDUITS WITH PULL STRING FOR AUDIO/VIDEO AND CONTROLS BACK TO TELLERS. COORDINATE EXACT LOCATION AND REQUIREMENTS WITH EQUIPMENT VENDOR
- 8 PROVIDE 30A./NF/208V./3-POLE/NEMA-3R DISCONNECT IN ACCESSIBLE LOCATION.
- 9 PROVIDE 20A./NF/208V./2-POLE/NEMA-1 HD TOGGLE SWITCH IN ACCESSIBLE LOCATION FOR WATER HEATER.
- 10 PROVIDE 30A./NF/208V./2-POLE/NEMA-3R DISCONNECT IN ACCESSIBLE LOCATION.
- 11 PROVIDE POWER TO LEAK DETECTION SYSTEM LOCATED NEAR WATER HEATER. COORDINATE WITH PLUMBING CONTRACTOR AND CIRCUIT TO NEAREST GENERAL PURPOSE CIRCUIT.
- 12 PROVIDE JUNCTION BOX FOR POWER TO TV. VERIFY LOCATION PRIOR TO INSTALLATION.
- 13 PROVIDE (2)-2" CONDUITS FOR FUTURE ATM POWER AND DATA. VERIFY LOCATION WITH OWNER AND ARCHITECT. PROVIDE WITH PULL-STRING, CAP AND TAG.
- 14 PROVIDE POWER FOR EXTERIOR BUILDING SIGN. VERIFY LOCATION WITH VENDOR PRIOR TO INSTALLATION.
- 15 PROVIDE POWER ABOVE CEILING FOR EXTERIOR SIGN. VERIFY LOCATION WITH ARCHITECT PRIOR TO INSTALLATION.

01 ELECTRICAL POWER PLAN
SCALE: 1/4"=1'-0"



E/B/E Mechanical
Electrical
Plumbing
12603 Southwest Fwy, Ste 170, Stafford, Tx 77477
Tel: (713) 840-0177 / Firm Reg. No: 5638