



NBT
National Bank & Trust
National Bank & Trust - Bastrop

Enter address here

E/BE Project Number : 26129.00

ISSUED FOR CLIENT APPROVAL	DATE
ISSUED FOR BIDDING	09/11/26
ISSUED FOR PERMIT	09/11/26
ISSUED FOR CONSTRUCTION	

REVISIONS

MARK	DESCRIPTION	DATE
	70% REVIEW SET	07/29/26
	90% REVIEW SET	08/20/26
	ISSUE FOR PERMIT & BID	09/11/26

The information, ideas, designs, details, layouts, techniques, features, arrangements, plans, sequences, dimensions, allowances, tolerances, concepts, specifications, intentions, technology or embodiments, as illustrated, arranged, described, or otherwise reduced to tangible form herein, either expressly, implicitly, or by implication, are the confidential and proprietary information of SUI Design, Inc., and shall remain the confidential and proprietary information of SUI Design, Inc. as identified on the drawing title block or legend for which they are and have been prepared by SUI Design, Inc. Any other reproduction, disclosure or use of any portion of the confidential and proprietary information of SUI Design, Inc. shall be a violation of the confidential and proprietary information of SUI Design, Inc. and shall constitute a breach of the Confidential and Proprietary Information Agreement from SUI Design, Inc. for a specific project or contract. Any copying, duplicating, reproducing, utilization, alteration, modification, revision or change to this drawing, or any portion thereof, without the written consent of SUI Design, Inc. SUI Design, Inc., and shall not be undertaken without receipt of such prior written approval. This drawing is loaned by SUI Design, Inc., for the limited purpose of complying with a specific Contract. The drawing remains the property of SUI Design, Inc. and shall remain the confidential and proprietary information of SUI Design, Inc. unless specifically authorized by Contract, under which it was loaned.




09/11/2026

DRAWING TITLE

ELECTRICAL PLAN - ATTIC

SHEET NO.

E3.10

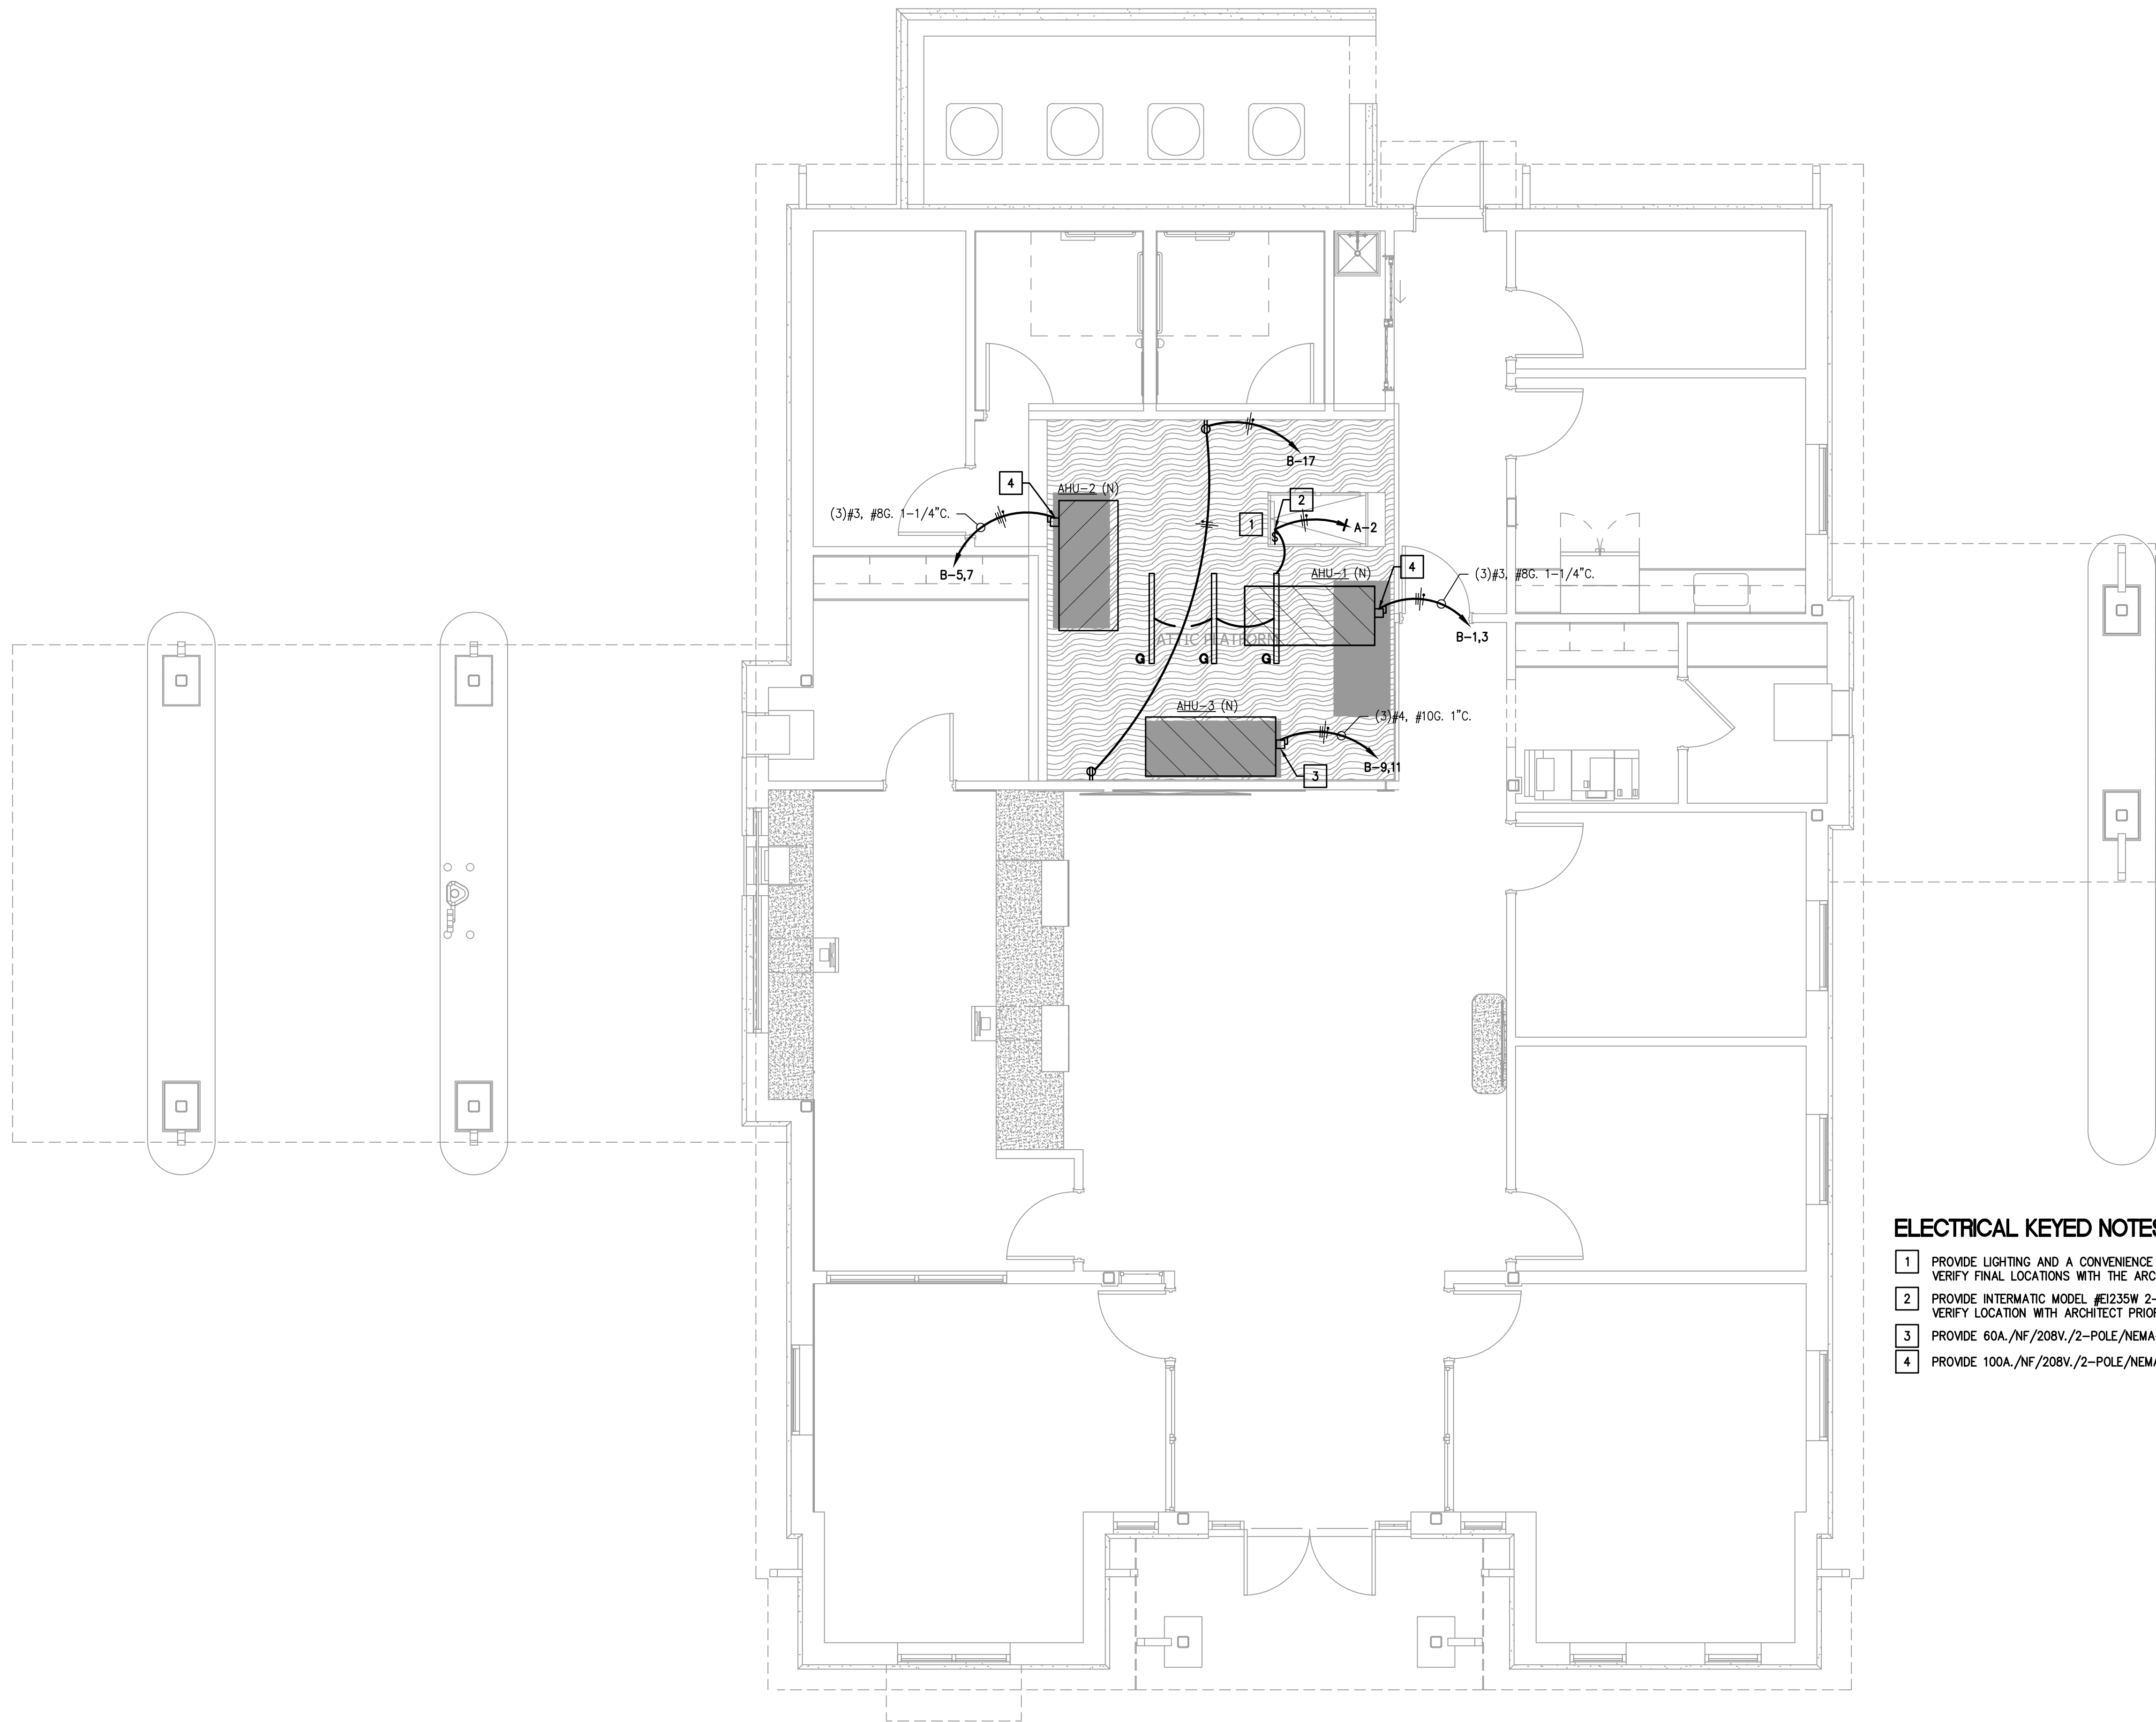

ELECTRICAL KEYED NOTES:

- 1 PROVIDE LIGHTING AND A CONVENIENCE RECEPTACLE IN THE ATTIC SPACE AS INDICATED. VERIFY FINAL LOCATIONS WITH THE ARCHITECT.
- 2 PROVIDE INTERMATIC MODEL #E1235W 2-HOUR ELECTRONIC COUNTDOWN TIMER SWITCH. VERIFY LOCATION WITH ARCHITECT PRIOR TO INSTALLATION.
- 3 PROVIDE 60A./NF/208V./2-POLE/NEMA-1 DISCONNECT IN ACCESSIBLE LOCATION.
- 4 PROVIDE 100A./NF/208V./2-POLE/NEMA-1 DISCONNECT IN ACCESSIBLE LOCATION.

01 ELECTRICAL PLAN - ATTIC

SCALE: 1/4"=1'-0"



E B E Mechanical
CONSULTING ENGINEERS Electrical Plumbing
12603 Southwest Frwy, Ste 170, Stafford, Tx 77477
Tel: (713) 840-0177 / Firm Reg. No: 5638