


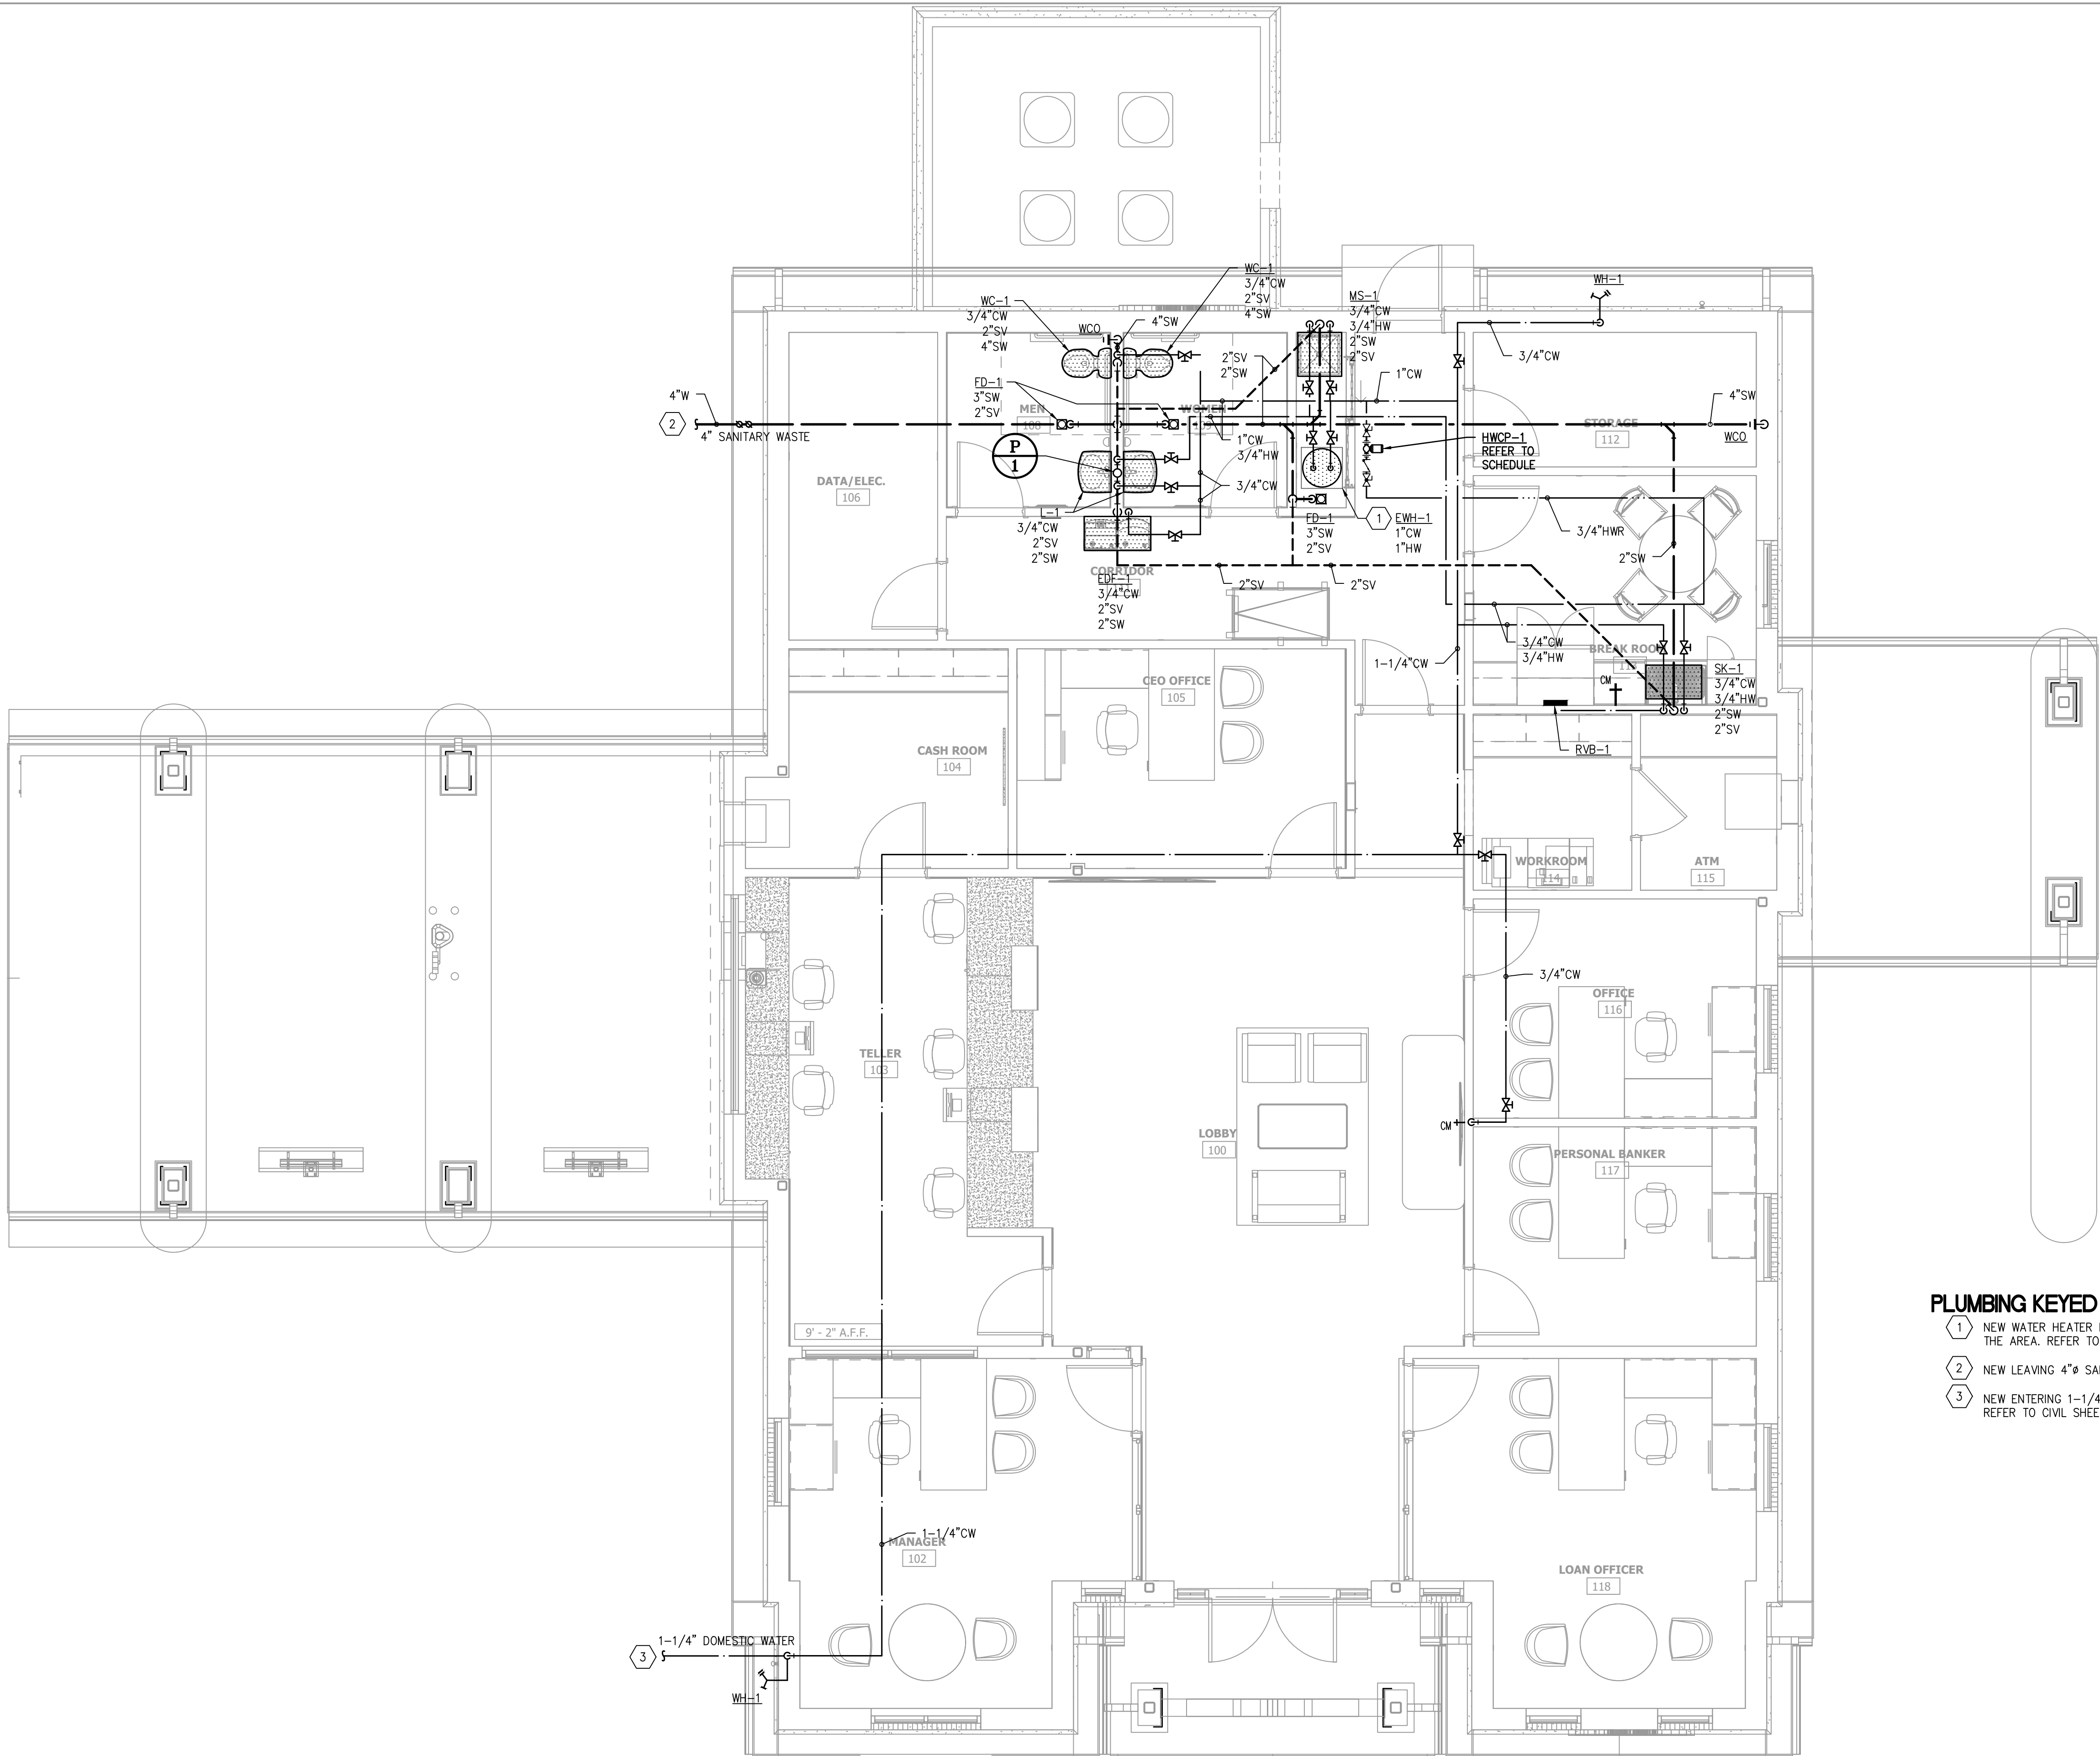

- PLUMBING KEYED NOTES:**
- 1 NEW WATER HEATER INSTALLED WITH WALL BRACING. COORDINATE WITH MEP IN THE AREA. REFER TO DETAILS.
 - 2 NEW LEAVING 4"Ø SANITARY WASTE. REFER TO CIVIL SHEET FOR CONTINUATION.
 - 3 NEW ENTERING 1-1/4"Ø DOMESTIC WATER SERVICE ENTRY. REFER TO DETAILS. REFER TO CIVIL SHEET FOR CONTINUATION.

01 PLUMBING PLAN
SCALE: 1/4"=1'-0"



E/B/E Mechanical
Electrical
CONSULTING ENGINEERS Plumbing
12603 Southwest Fwy, Ste 170, Stafford, Tx 77477
Tel: (713) 840-0177 / Firm Reg. No: 5638



ARCHITECTURE | DESIGN | CONSTRUCTION
15810 PARK TEN PLACE, SUITE 300
HOUSTON, TEXAS 77084
713-465-4650
www.sligroup.com

NBT
National Bank & Trust
National Bank & Trust - Bastrop
Enter address here

E/BE Project Number : 26129.00

ISSUED FOR CLIENT APPROVAL	DATE
ISSUED FOR BIDDING	09/11/26
ISSUED FOR PERMIT	09/11/26
ISSUED FOR CONSTRUCTION	

REVISIONS		
MARK	DESCRIPTION	DATE
	70% REVIEW SET	07/29/26
	90% REVIEW SET	08/20/26
	ISSUE FOR PERMIT & BID	09/11/26

The information, ideas, designs, details, layouts, techniques, features, arrangements, plans, sequences, dimensions, allowances, tolerances, conceptions, specifications, intentions, technology or embodiments, as illustrated, arranged, displayed, noted, recorded, indicated, represented, disclosed, evidenced, detailed or otherwise reduced to tangible form hereon, either expressly, inherently or by implication, are the confidential and proprietary information of SLI Design, Inc., and shall not be used for any purpose other than the specific project or undertaking identified on the drawing title block or legend for which they are and have been prepared by SLI Design, Inc. Any other reproduction, disclosure or use of any portion of the confidential and proprietary information of SLI Design, Inc., shall be a breach of the obligation of confidence created by the acceptance of this drawing from SLI Design, Inc. for a specific project or Contract. Any copying, duplicating, reproducing, utilization, alteration, modification, revision or change to this drawing, is expressly prohibited unless done with the prior written consent or approval of SLI Design, Inc., and shall not be undertaken without receipt of such prior written approval. This drawing is loaned by SLI Design, Inc., for the limited purpose of complying with a specific Contract. The drawing remains the property of SLI Design, Inc., and shall be returned upon request or completion of the contract, unless specifically authorized by Contract, under which it was loaned.



09/11/2026

DRAWING TITLE	
PLUMBING PLAN	SHEET NO.
	P-1.10